


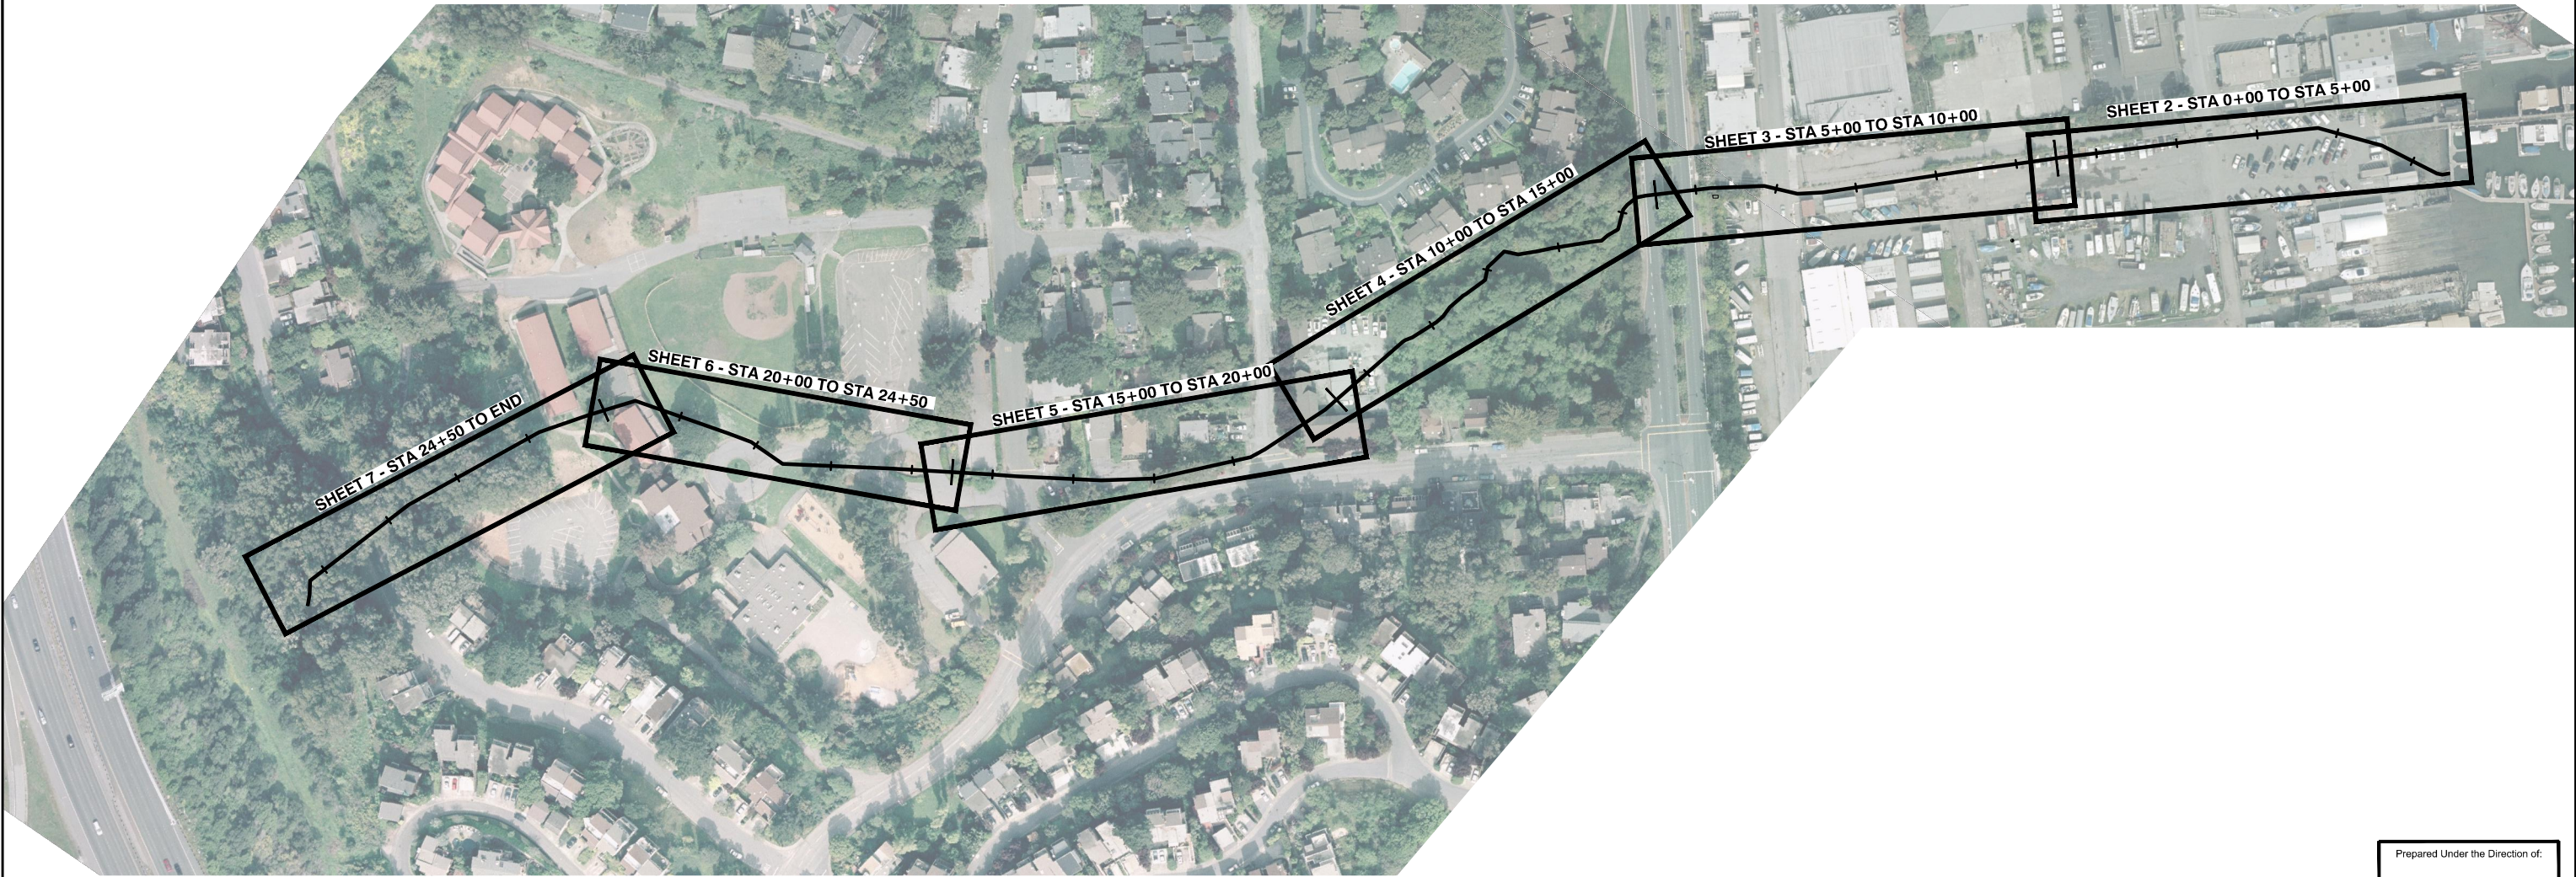


KEY MAP
1" = 100'

Prepared Under the Direction of:


1"
IF THIS DOES NOT MEASURE ONE INCH,
THESE PLANS ARE NOT TO SCALE.

	09/19/13	35% Progress Set		PM	
NO.	DATE		REVISION	BY	APP.
FRIENDS OF WILLOW CREEK, SAUSALITO					
WILLOW CREEK DAYLIGHTING PLAN					
KEY MAP					

AND NOTES					
DES	DR	CH	SCALE	AS SHOWN	
XX	PM	XX	DATE	11/23/13	
APPROVED:			SHEET NO. 1 OF 7 SHEETS		
_____			JOB.NO.		

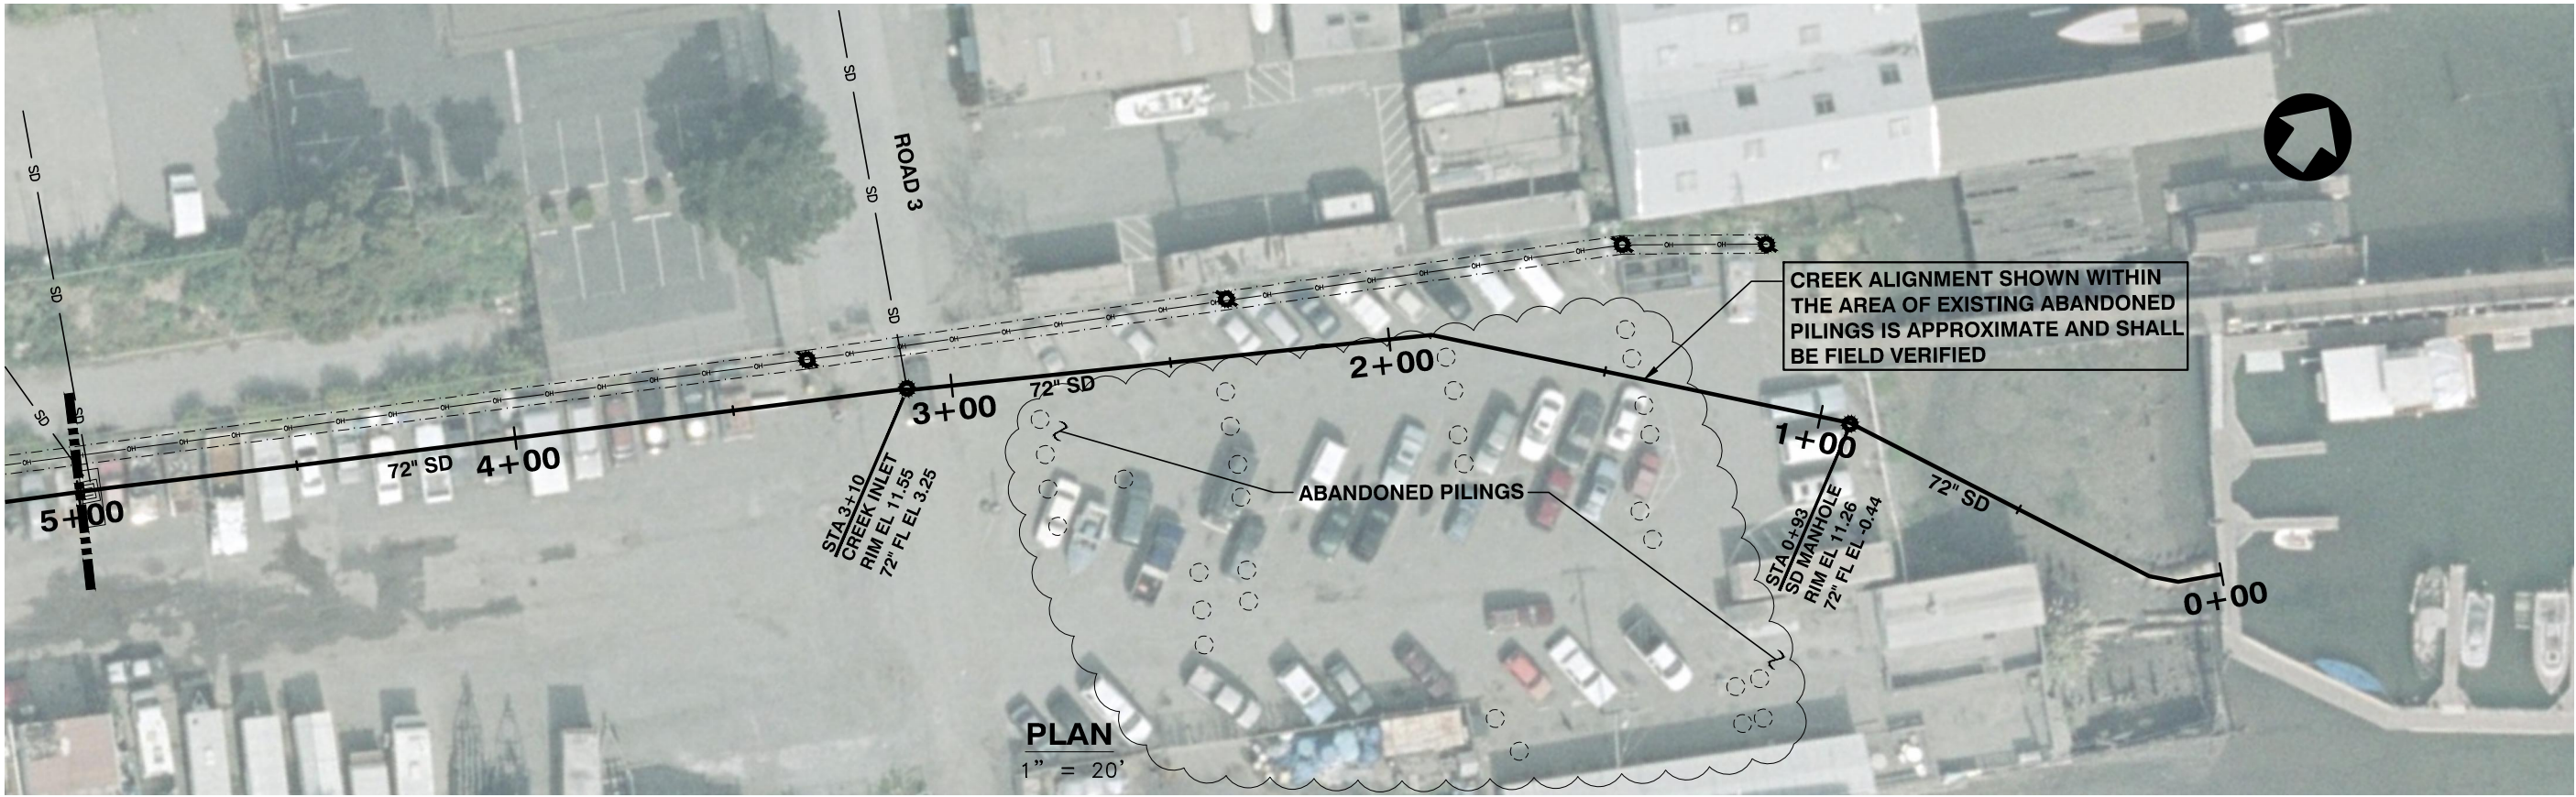

PLAN
1" = 20'

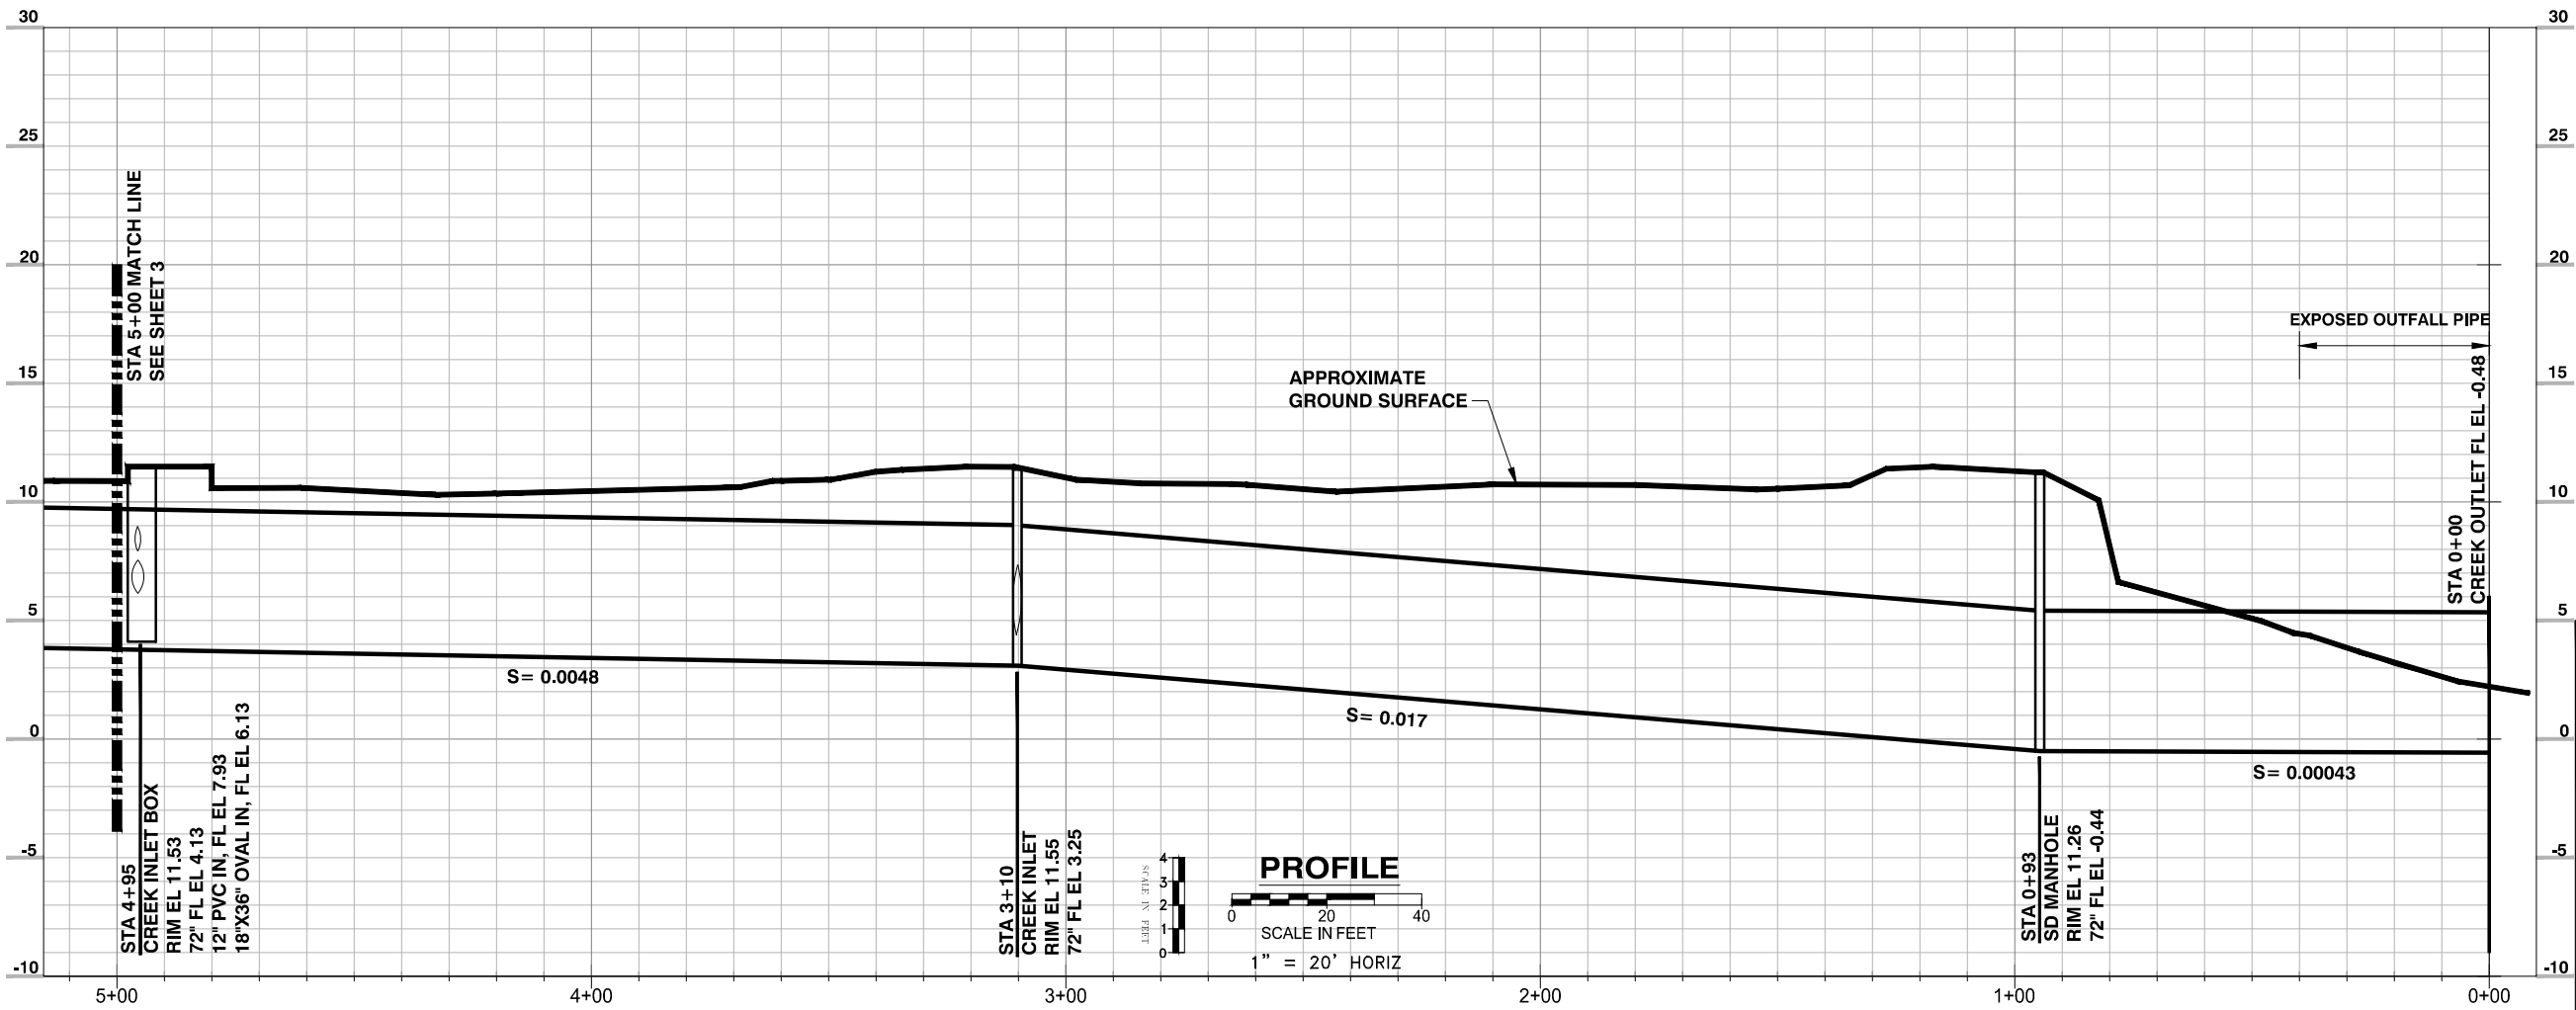

PROFILE



SCALE IN FEET
1" = 20' HORIZ

Prepared Under the Direction of:

1"
IF THIS DOES NOT MEASURE ONE INCH,
THESE PLANS ARE NOT TO SCALE.

	09/19/13	35% Progress Set		PM	
NO.	DATE		REVISION	BY	APP.
FRIENDS OF WILLOW CREEK, SAUSALITO					
WILLOW CREEK DAYLIGHTING PLAN					
PLAN AND PROFILE					

STA 0+00 TO STA 5+00					
DES	DR	CH	SCALE	AS SHOWN	
XX	PM	XX	DATE	11/23/13	
APPROVED:			SHEET NO. 2 OF 7 SHEETS		
_____			JOB.NO.		

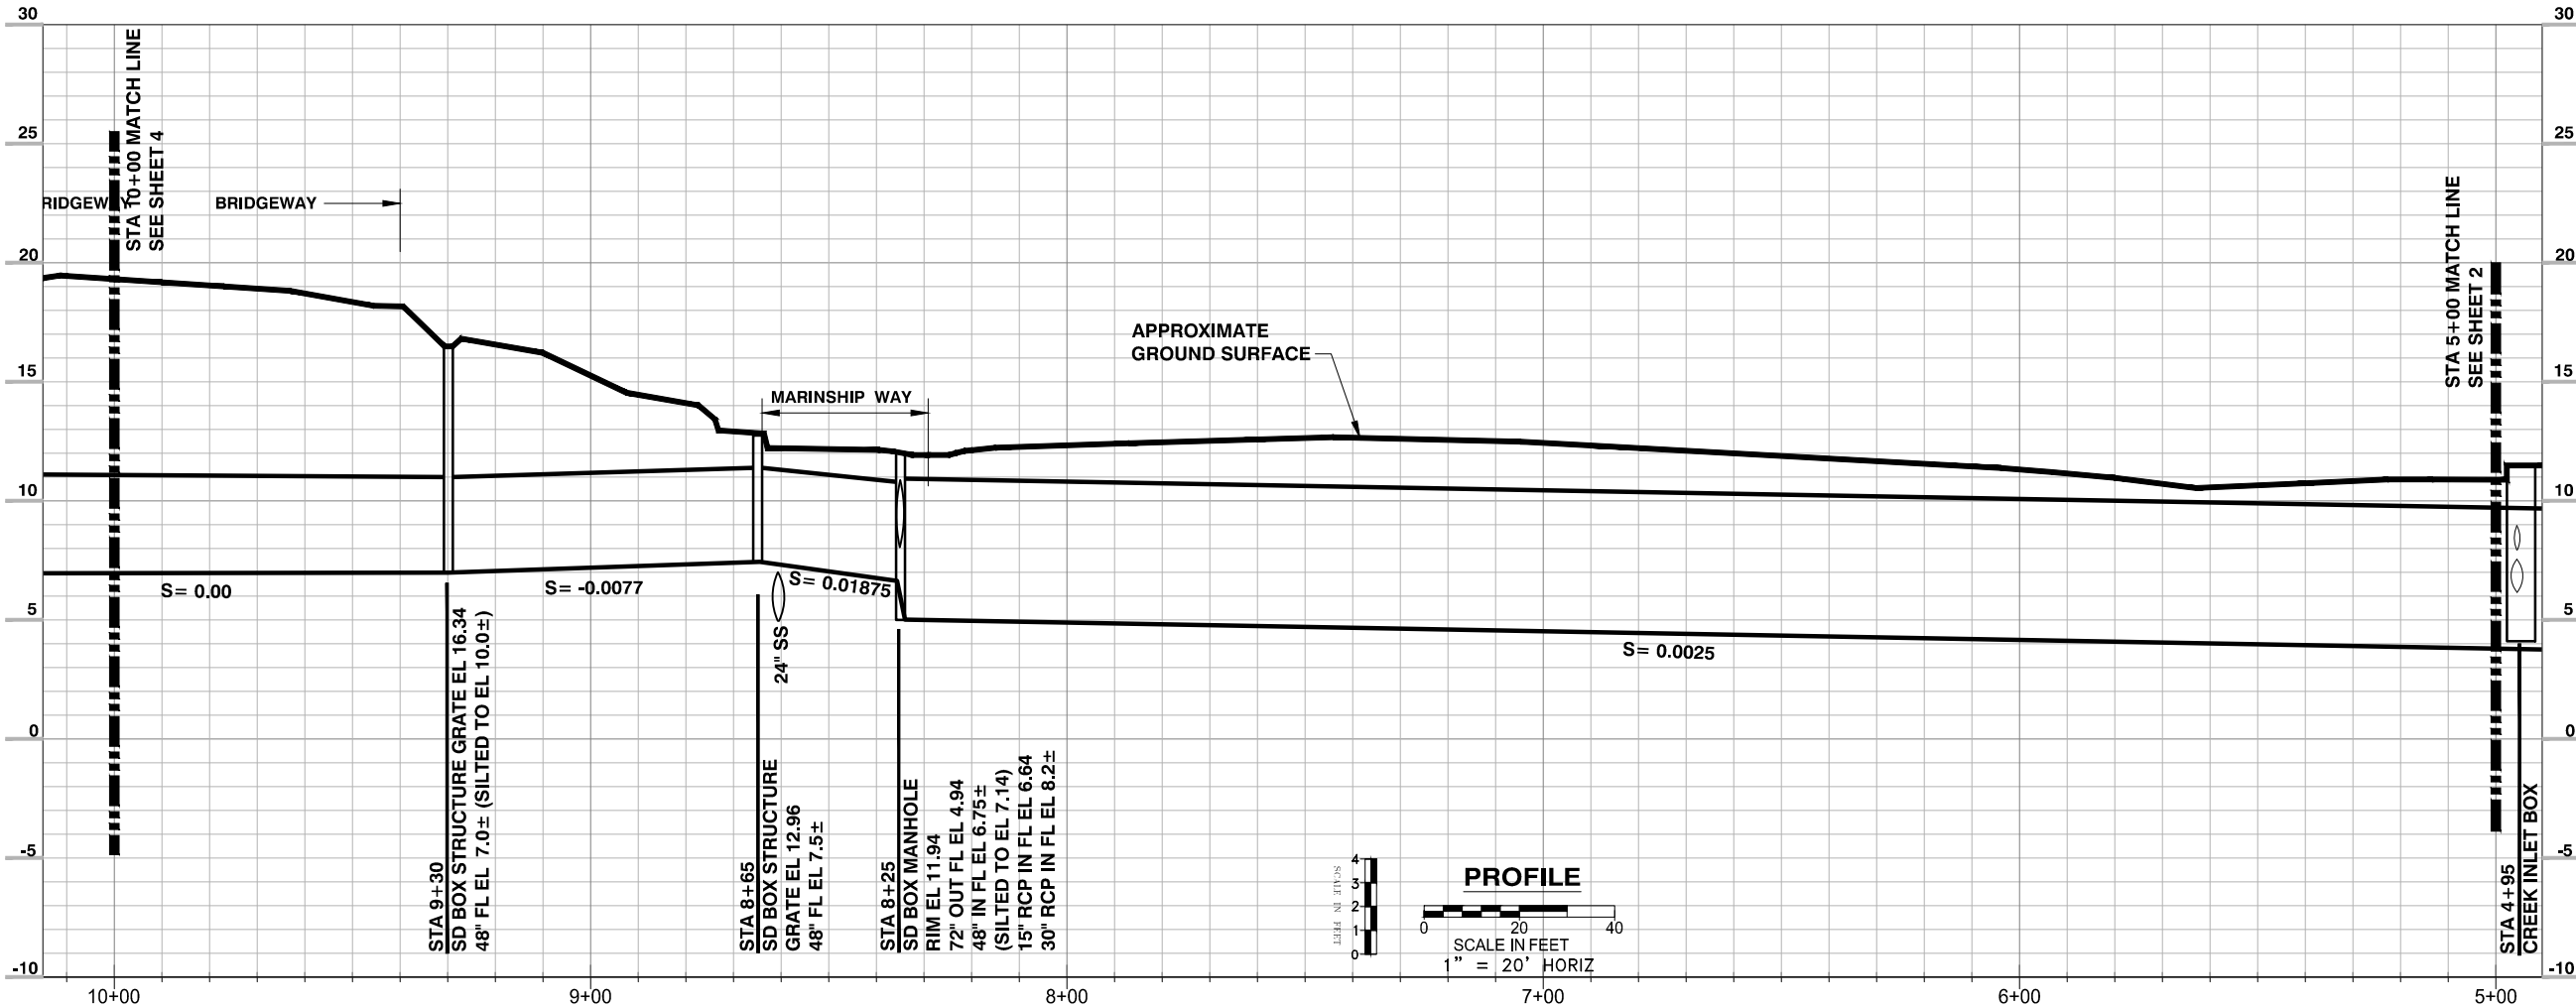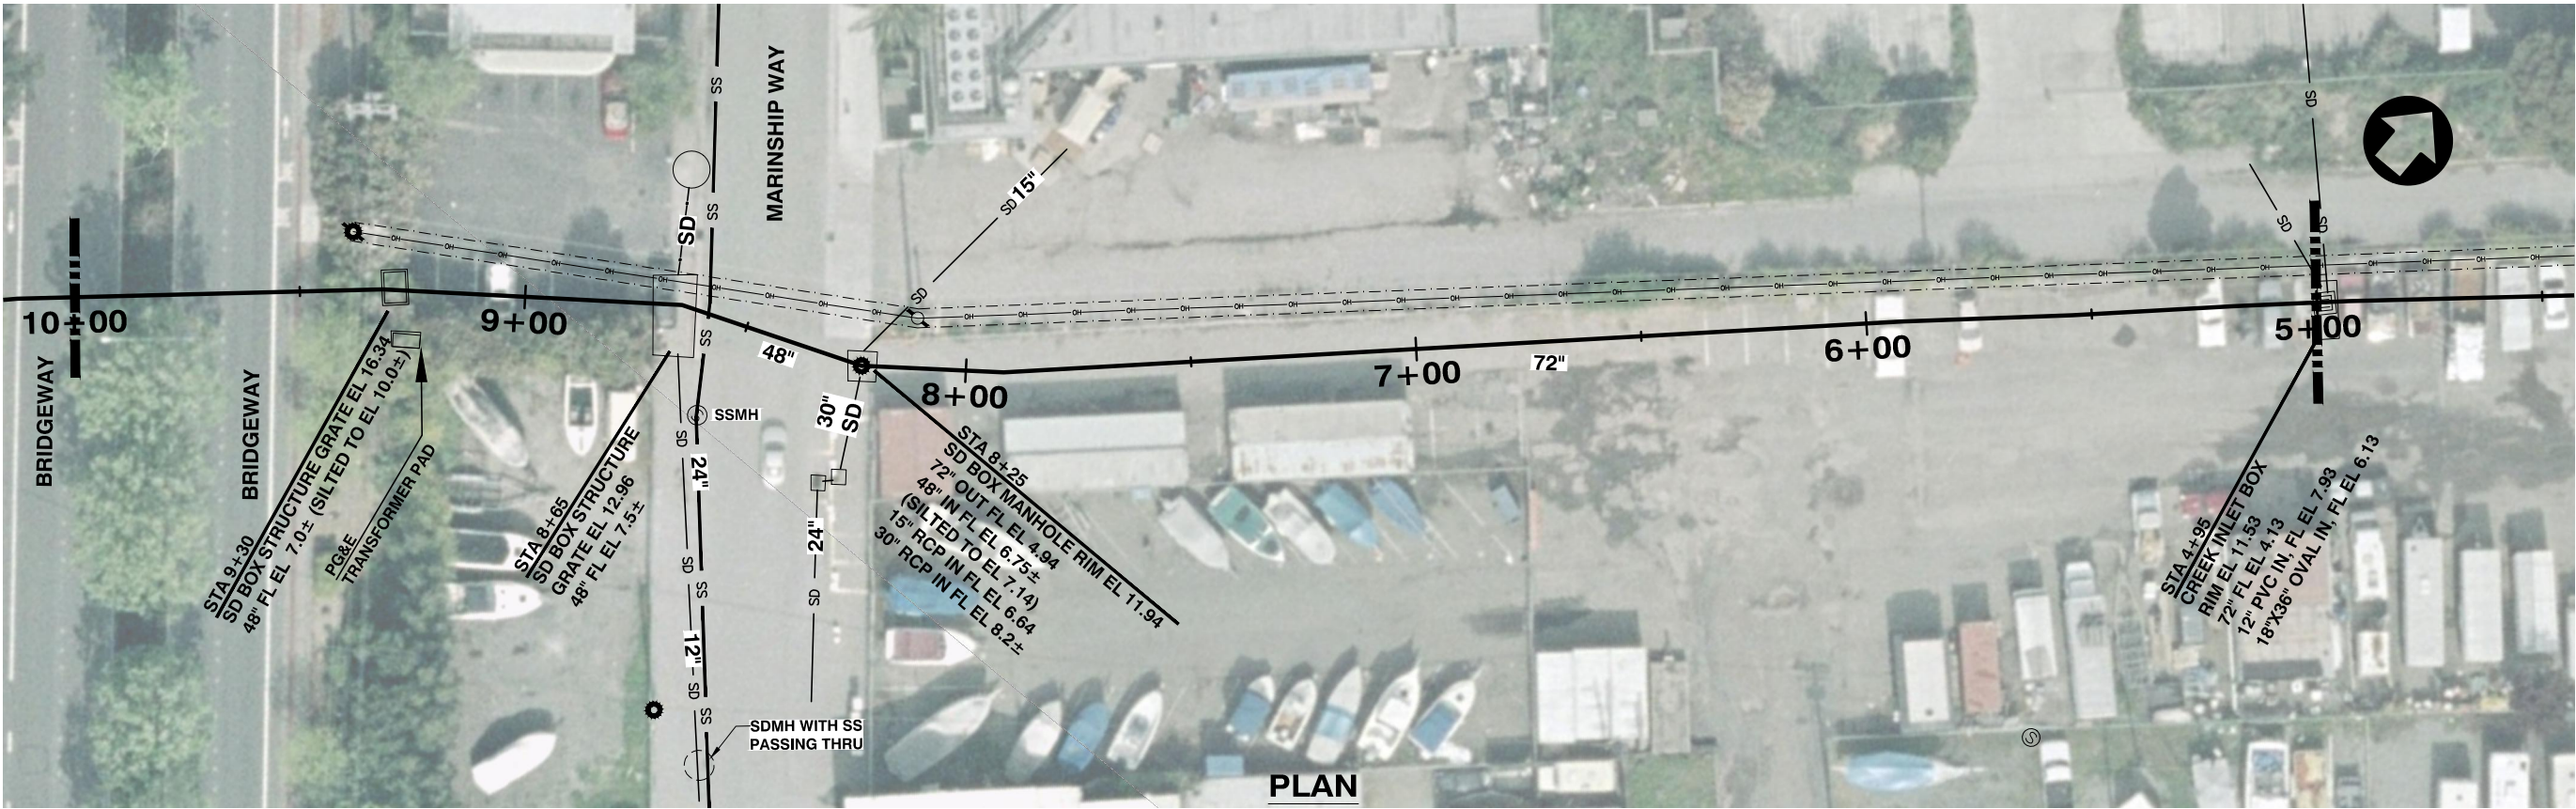


Prepared Under the Direction of:


1"
IF THIS DOES NOT MEASURE ONE INCH,
THESE PLANS ARE NOT TO SCALE.

	09/19/13	35% Progress Set		PM	
NO.	DATE		REVISION	BY	APP.
FRIENDS OF WILLOW CREEK, SAUSALITO					
WILLOW CREEK DAYLIGHTING PLAN					
PLAN AND PROFILE					

STA 5+00 TO STA 10+00					
DES	DR	CH	SCALE	AS SHOWN	
XX	PM	XX	DATE	11/23/13	
APPROVED:			SHEET NO. 3 OF 7 SHEETS		
_____			JOB.NO.		

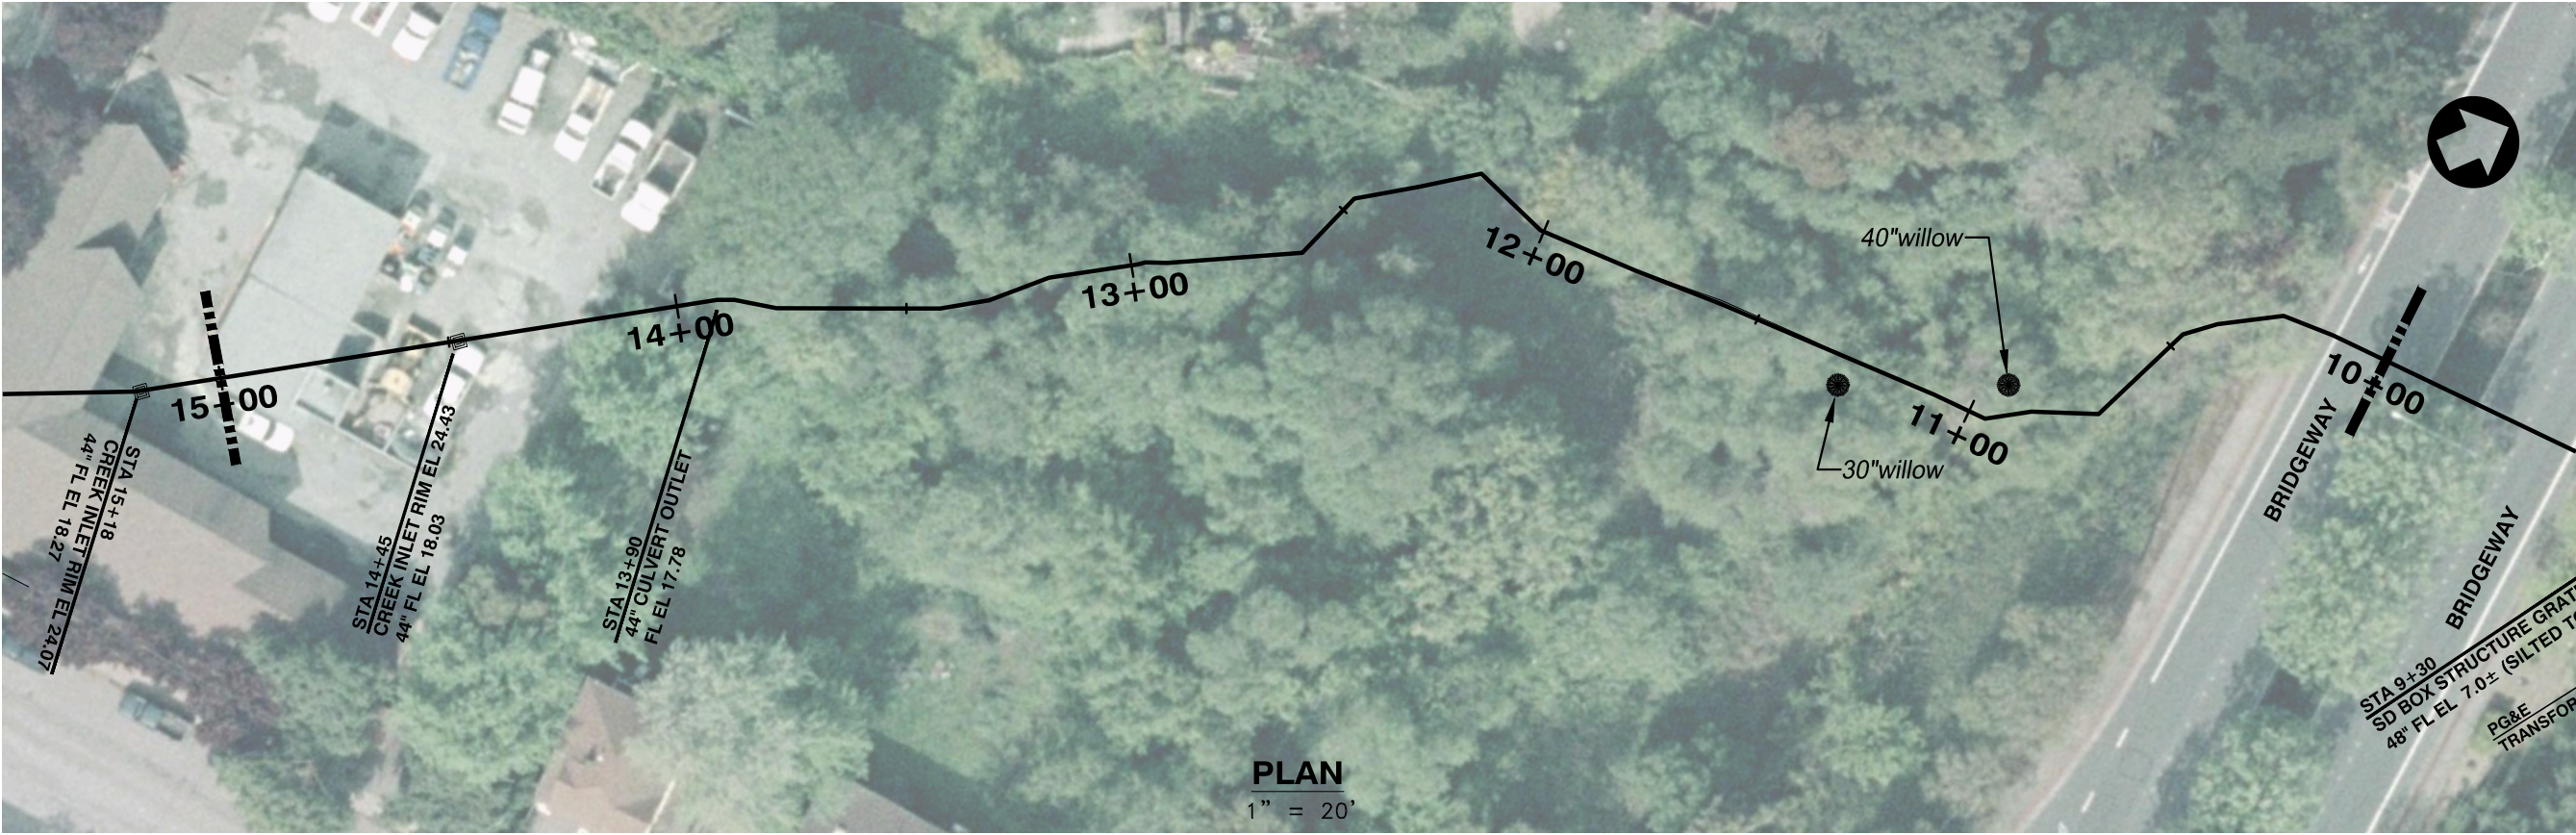

PLAN
1" = 20'

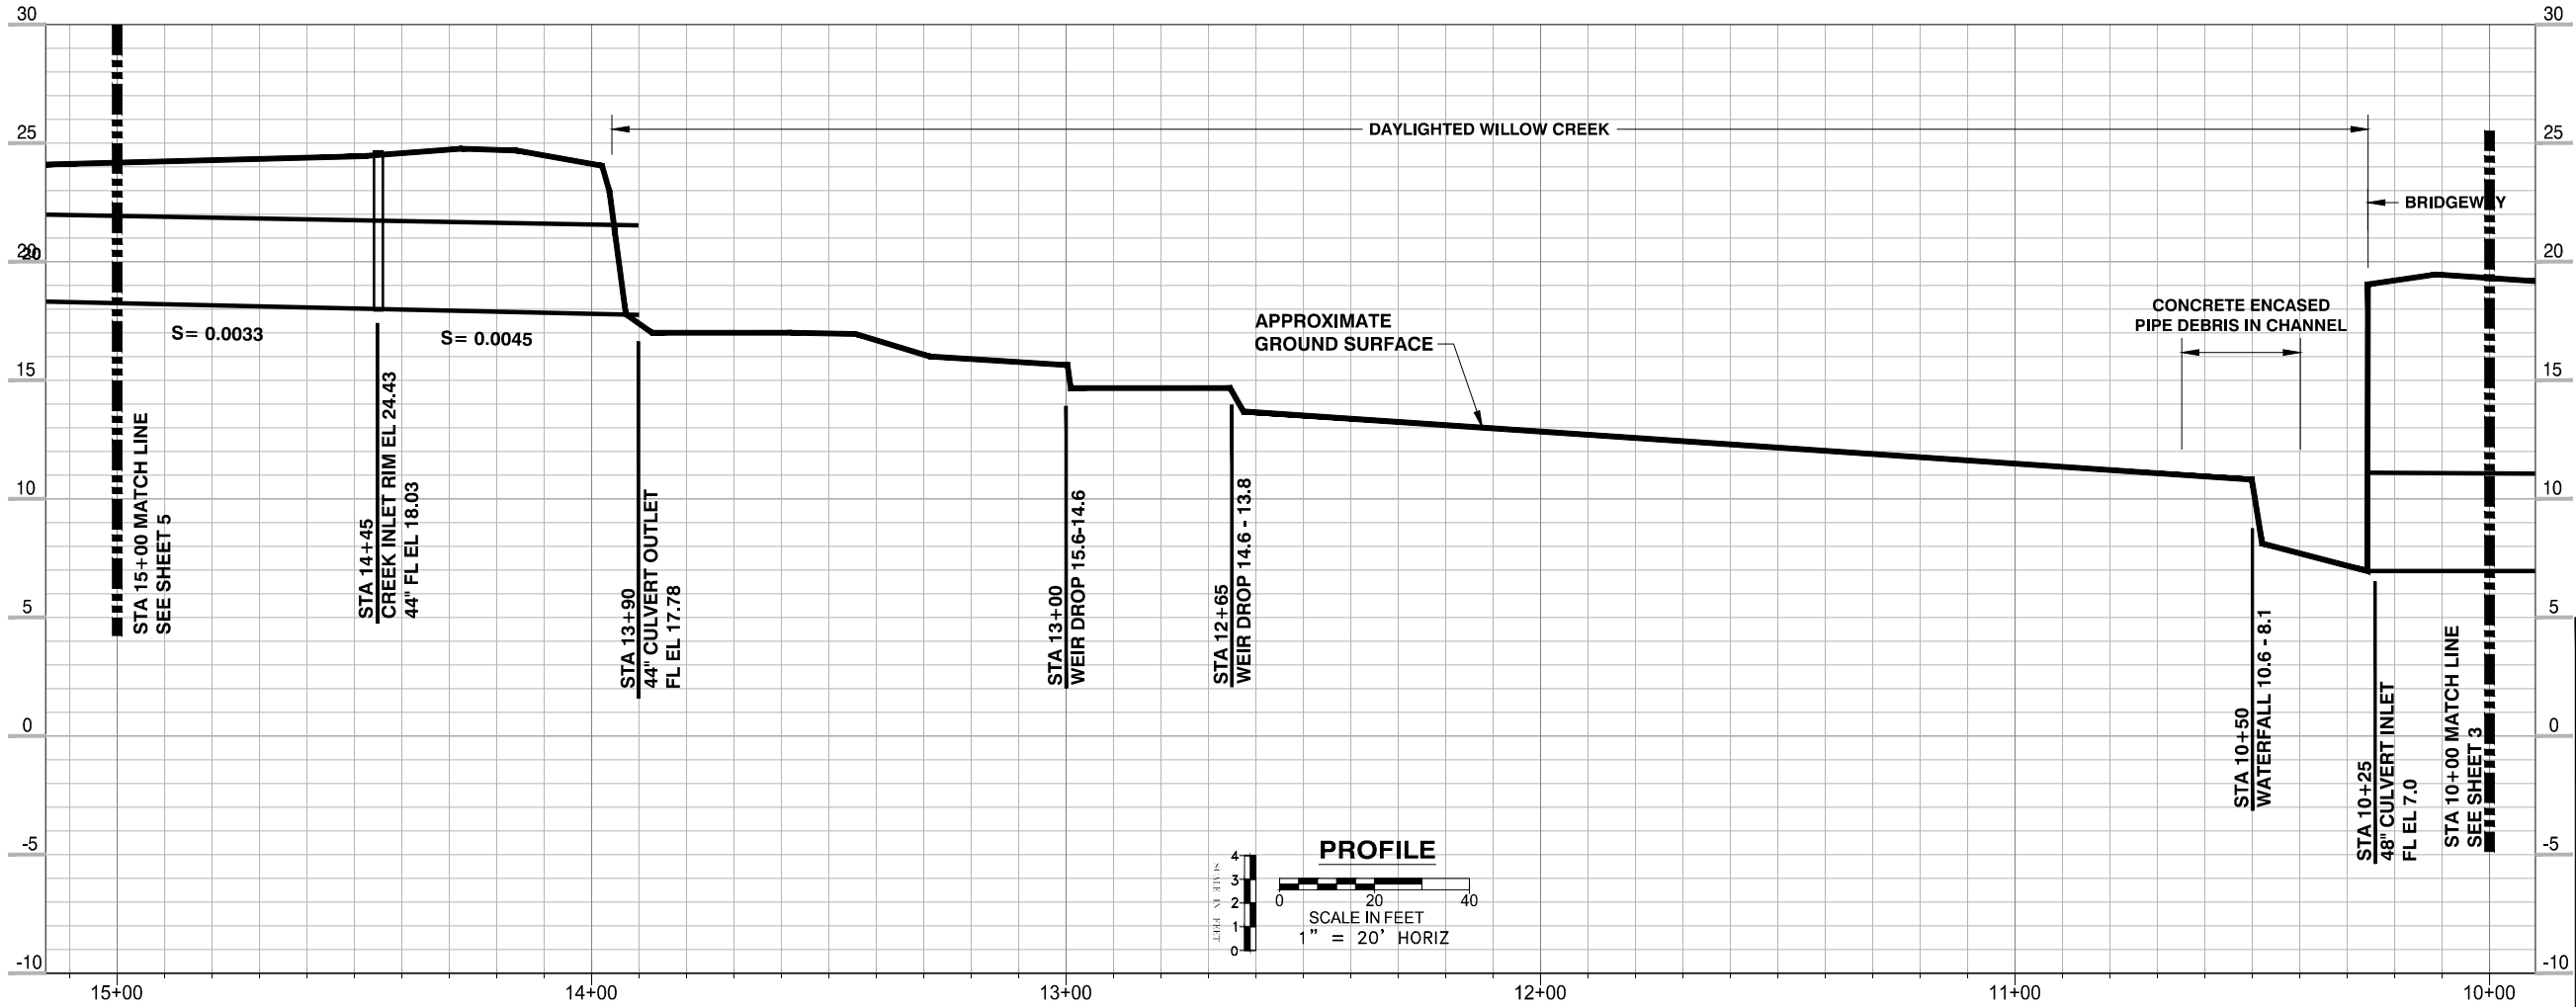

PROFILE



SCALE IN FEET
1" = 20' HORIZ

1"
IF THIS DOES NOT MEASURE ONE INCH,
THESE PLANS ARE NOT TO SCALE.

Prepared Under the Direction of:

	09/19/13	35% Progress Set		PM	
NO.	DATE		REVISION	BY	APP.
FRIENDS OF WILLOW CREEK, SAUSALITO					
WILLOW CREEK DAYLIGHTING PLAN					
PLAN AND PROFILE					



STA 10+00 TO STA 15+00					
DES	DR	CH	SCALE	AS SHOWN	
XX	PM	XX	DATE	11/23/13	
APPROVED:			SHEET NO. 4 OF 7 SHEETS		
_____			JOB.NO.		

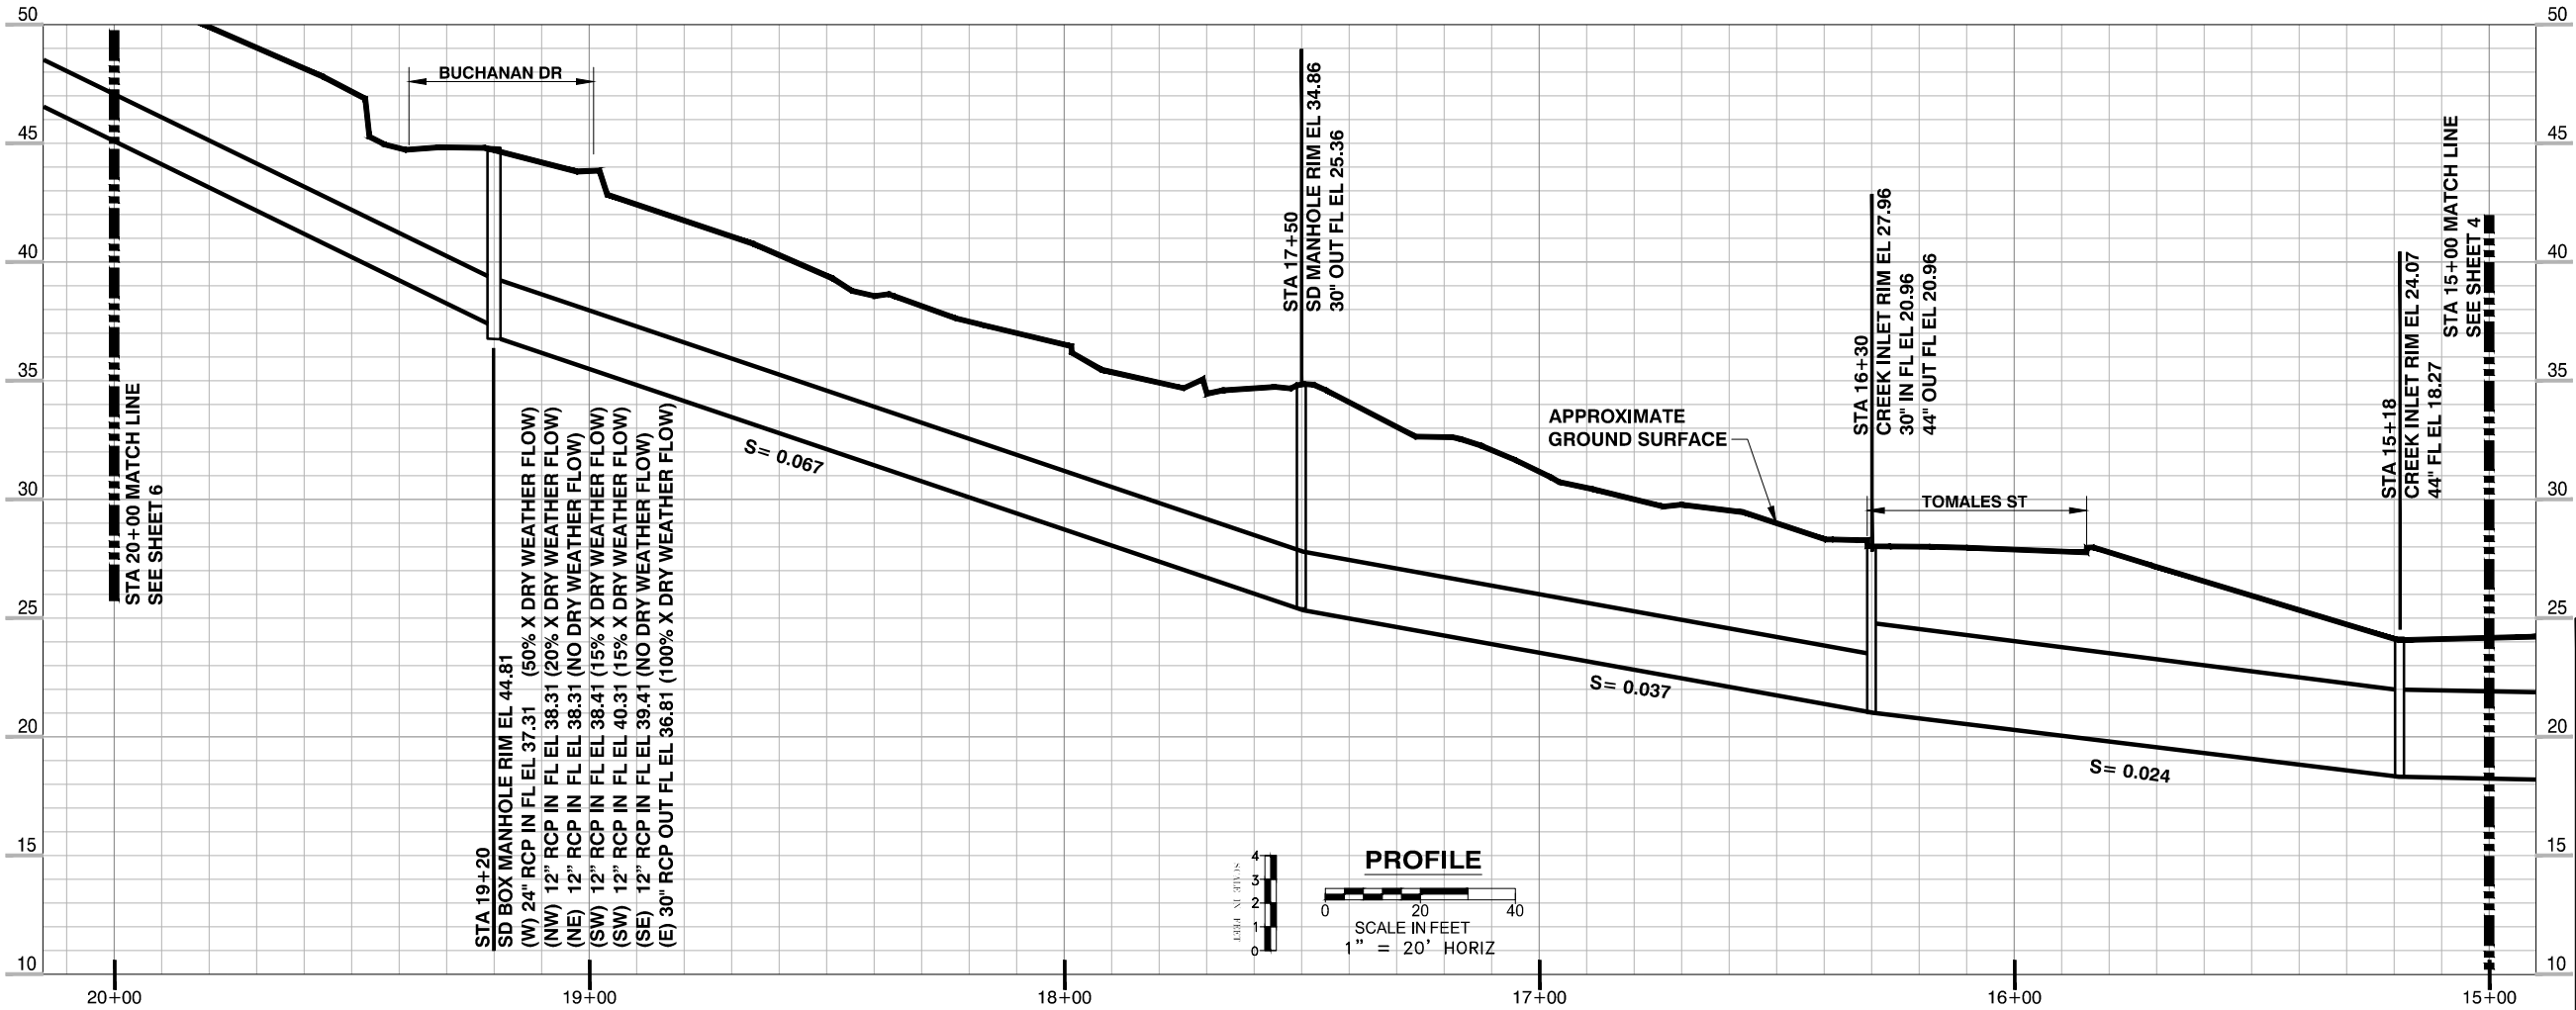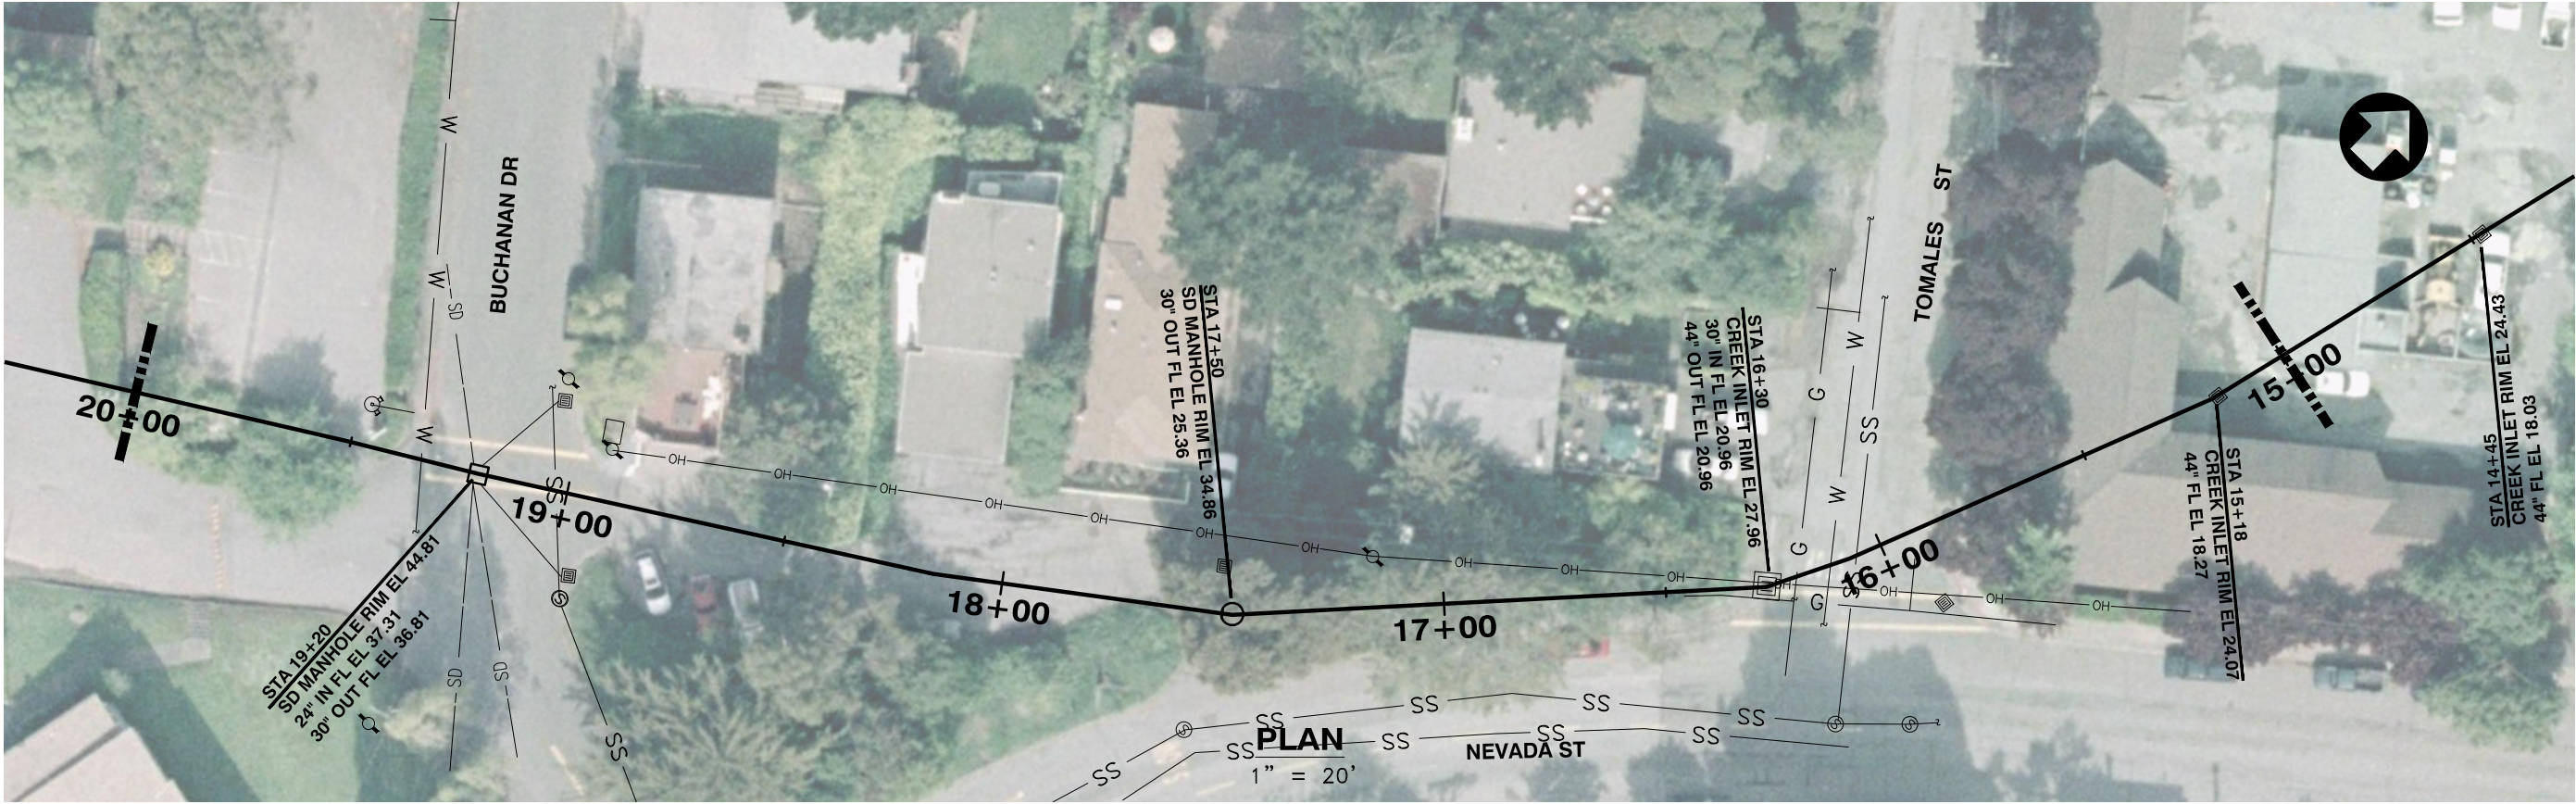

Prepared Under the Direction of:

1"
IF THIS DOES NOT MEASURE ONE INCH,
THESE PLANS ARE NOT TO SCALE.


NO.	09/19/13	35% Progress Set	PM
DATE	REVISION	BY	APP.
FRIENDS OF WILLOW CREEK, SAUSALITO			
WILLOW CREEK DAYLIGHTING PLAN			
PLAN AND PROFILE			
STA 15+00 TO STA 20+00			
DES	DR	CH	SCALE AS SHOWN
XX	PM	XX	DATE 11/23/13
APPROVED:		SHEET NO. 5 OF 7 SHEETS	
		JOB NO.	

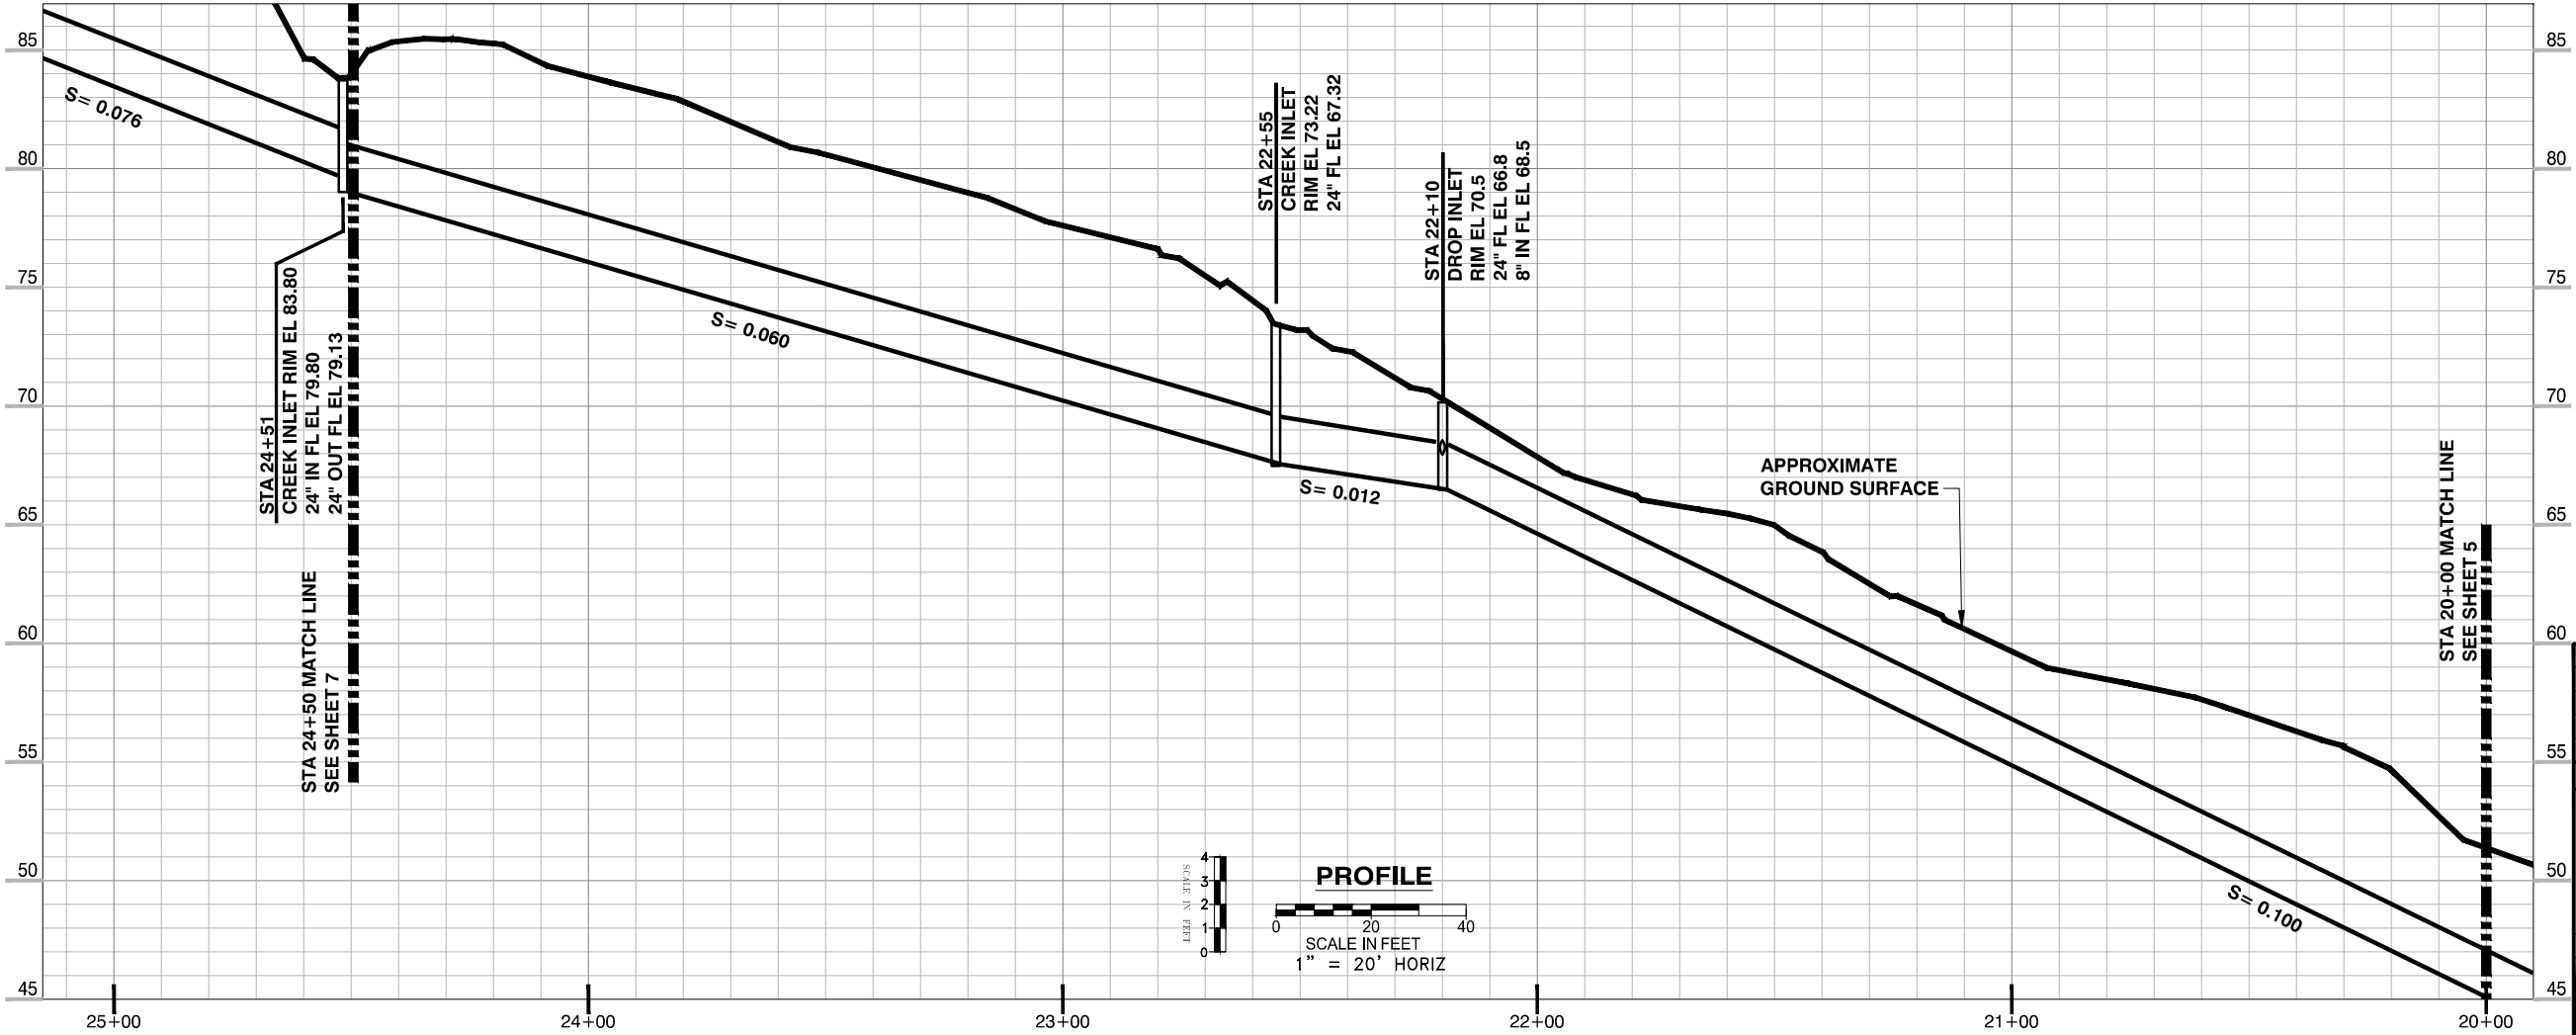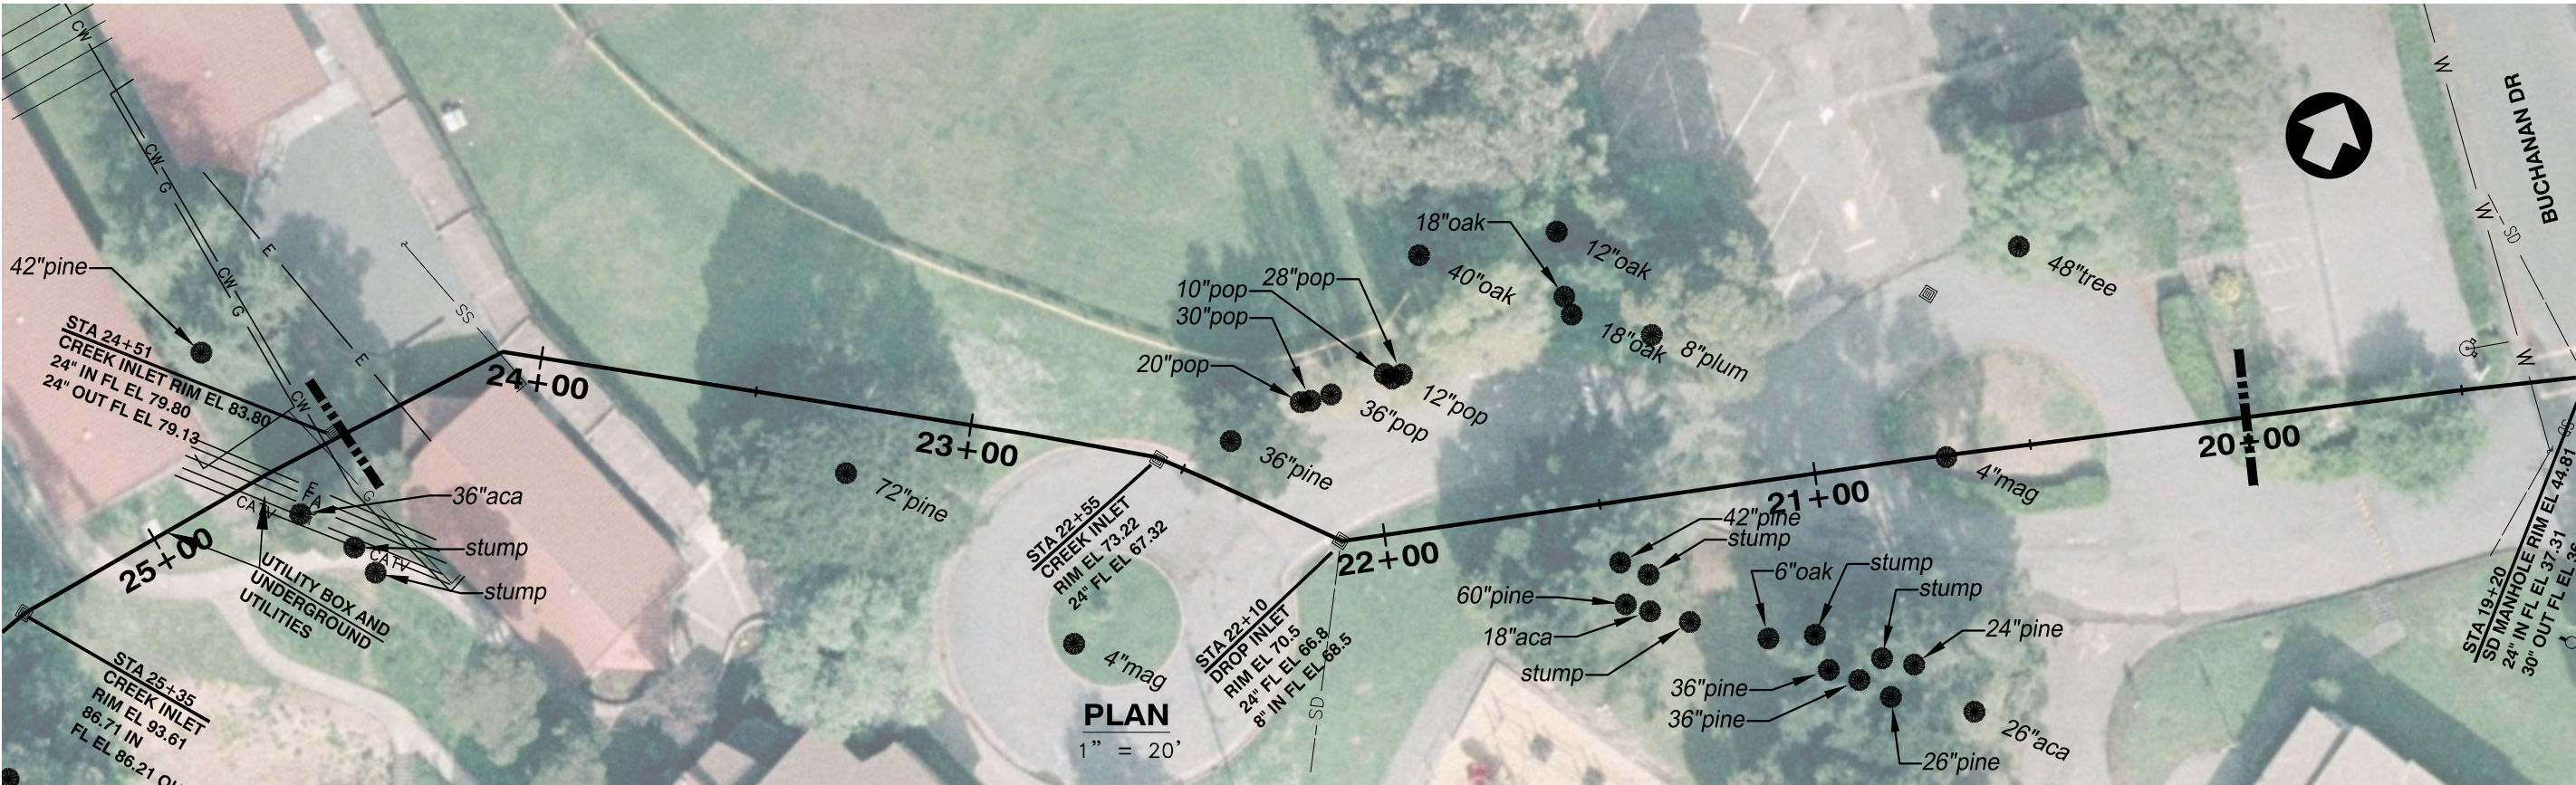

Prepared Under the Direction of:


1"
IF THIS DOES NOT MEASURE ONE INCH,
THESE PLANS ARE NOT TO SCALE.

	09/19/13	35% Progress Set			PM
NO.	DATE		REVISION	BY	APP.
FRIENDS OF WILLOW CREEK, SAUSALITO					
WILLOW CREEK DAYLIGHTING PLAN					
PLAN AND PROFILE					
STA 20+00 TO STA 24+50					
DES	DR	CH	SCALE	AS SHOWN	
XX	PM	XX	DATE	11/23/13	
APPROVED:			SHEET NO.	6 OF 7 SHEETS	
			JOB NO.		

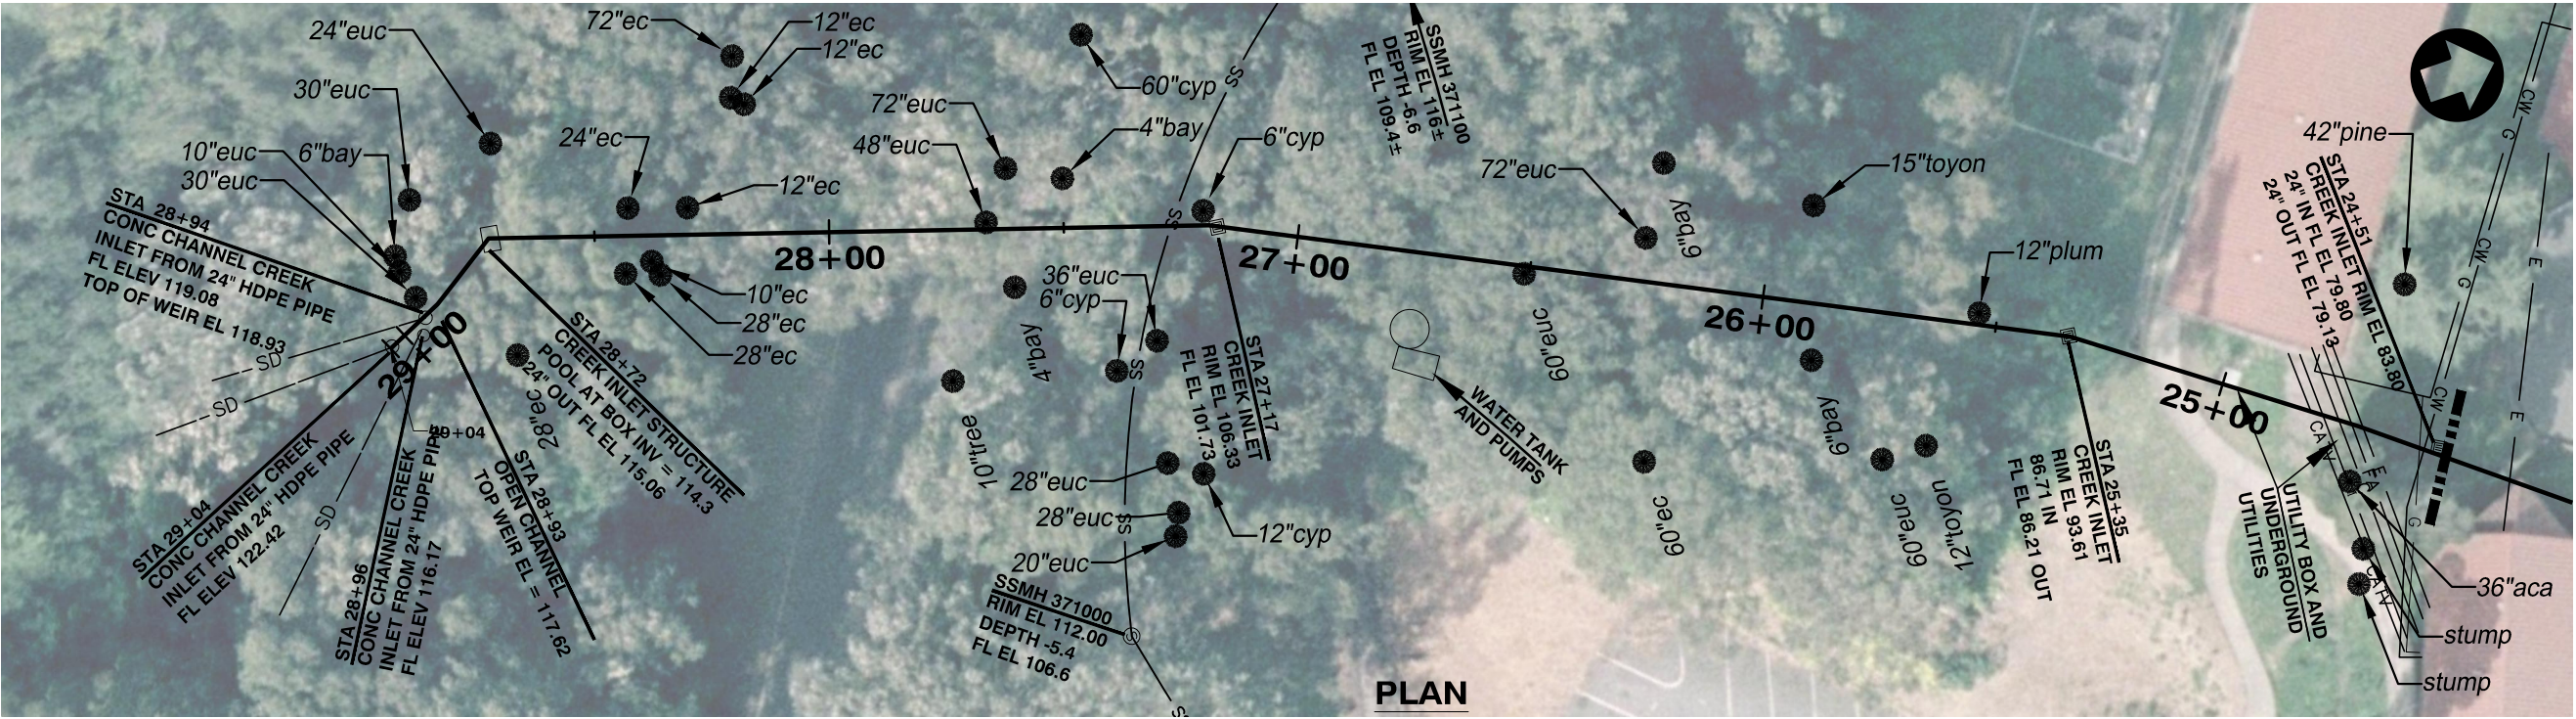


PLAN

1" = 20'

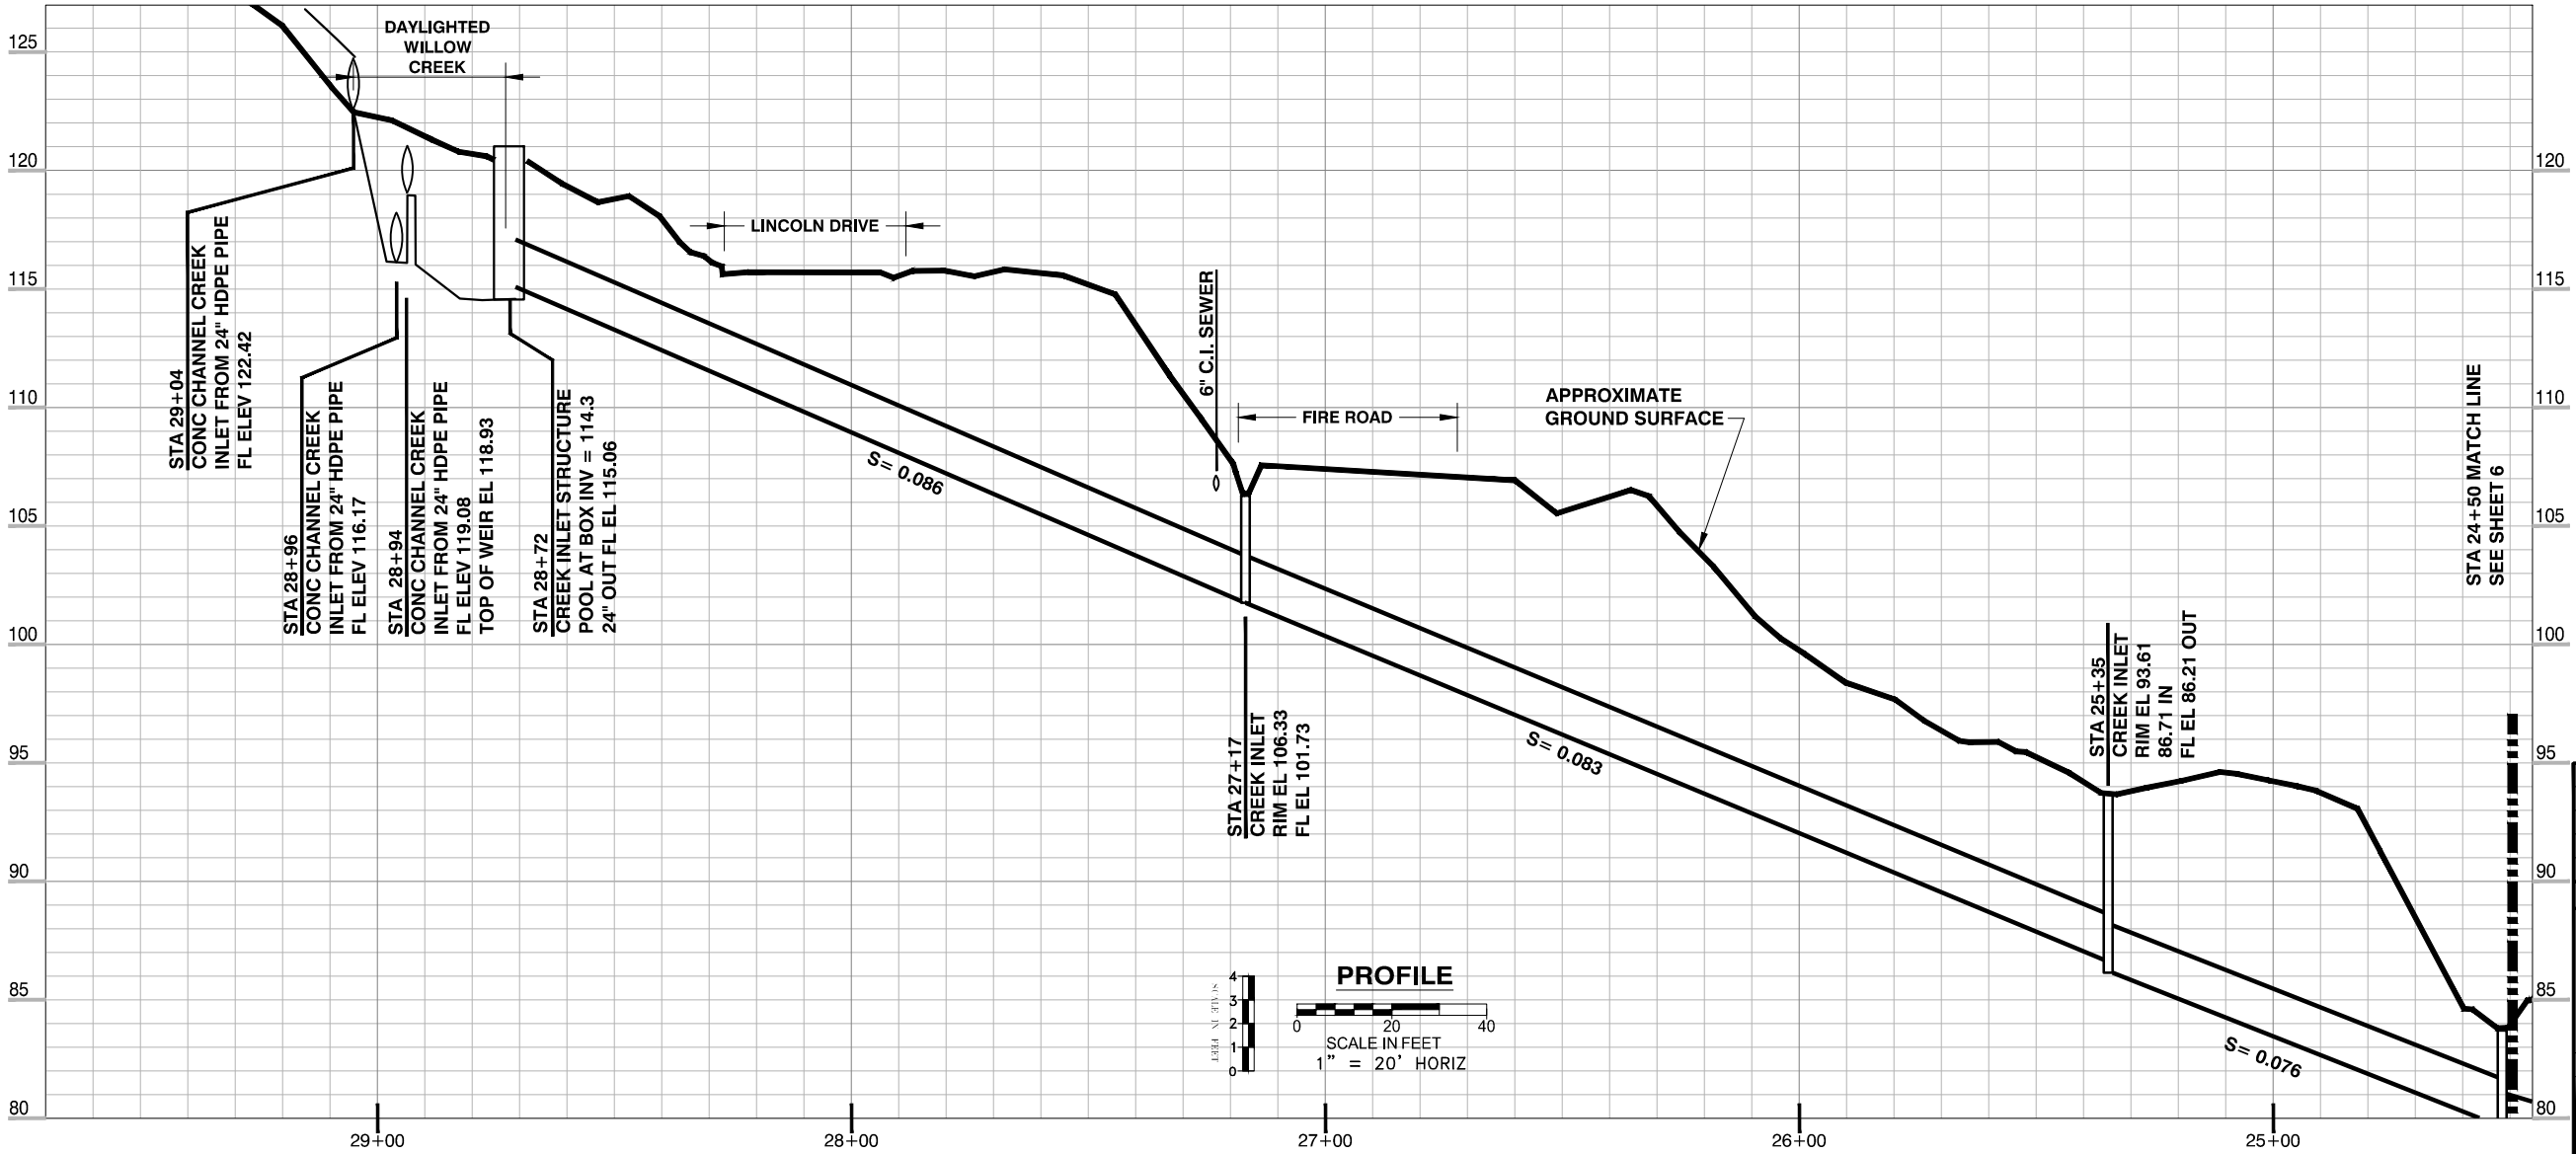

PROFILE

 

Prepared Under the Direction of:

1"
IF THIS DOES NOT MEASURE ONE INCH,
THESE PLANS ARE NOT TO SCALE.

	09/19/13	35% Progress Set		PM	
NO.	DATE		REVISION	BY	APP.
FRIENDS OF WILLOW CREEK, SAUSALITO					
WILLOW CREEK DAYLIGHTING PLAN					
PLAN AND PROFILE					

STA 24+50 TO END					
DES	DR	CH	SCALE	AS SHOWN	
XX	PM	XX	DATE	11/23/13	
APPROVED:			SHEET NO. 7 OF 7 SHEETS		
_____			JOB.NO.		