



DATE:	4/18/23	
SCALE:	1"=20'	
MAPPING BY:	BKS/ILW	
DESIGNED BY:	LWM/J	
DRAFTED BY:	LW	
CHECKED BY:	CW	
REVISIONS	DATE	BY


**WILLOW CREEK DAYLIGHTING
NORTH PERIMETER
CONCEPT PLAN**

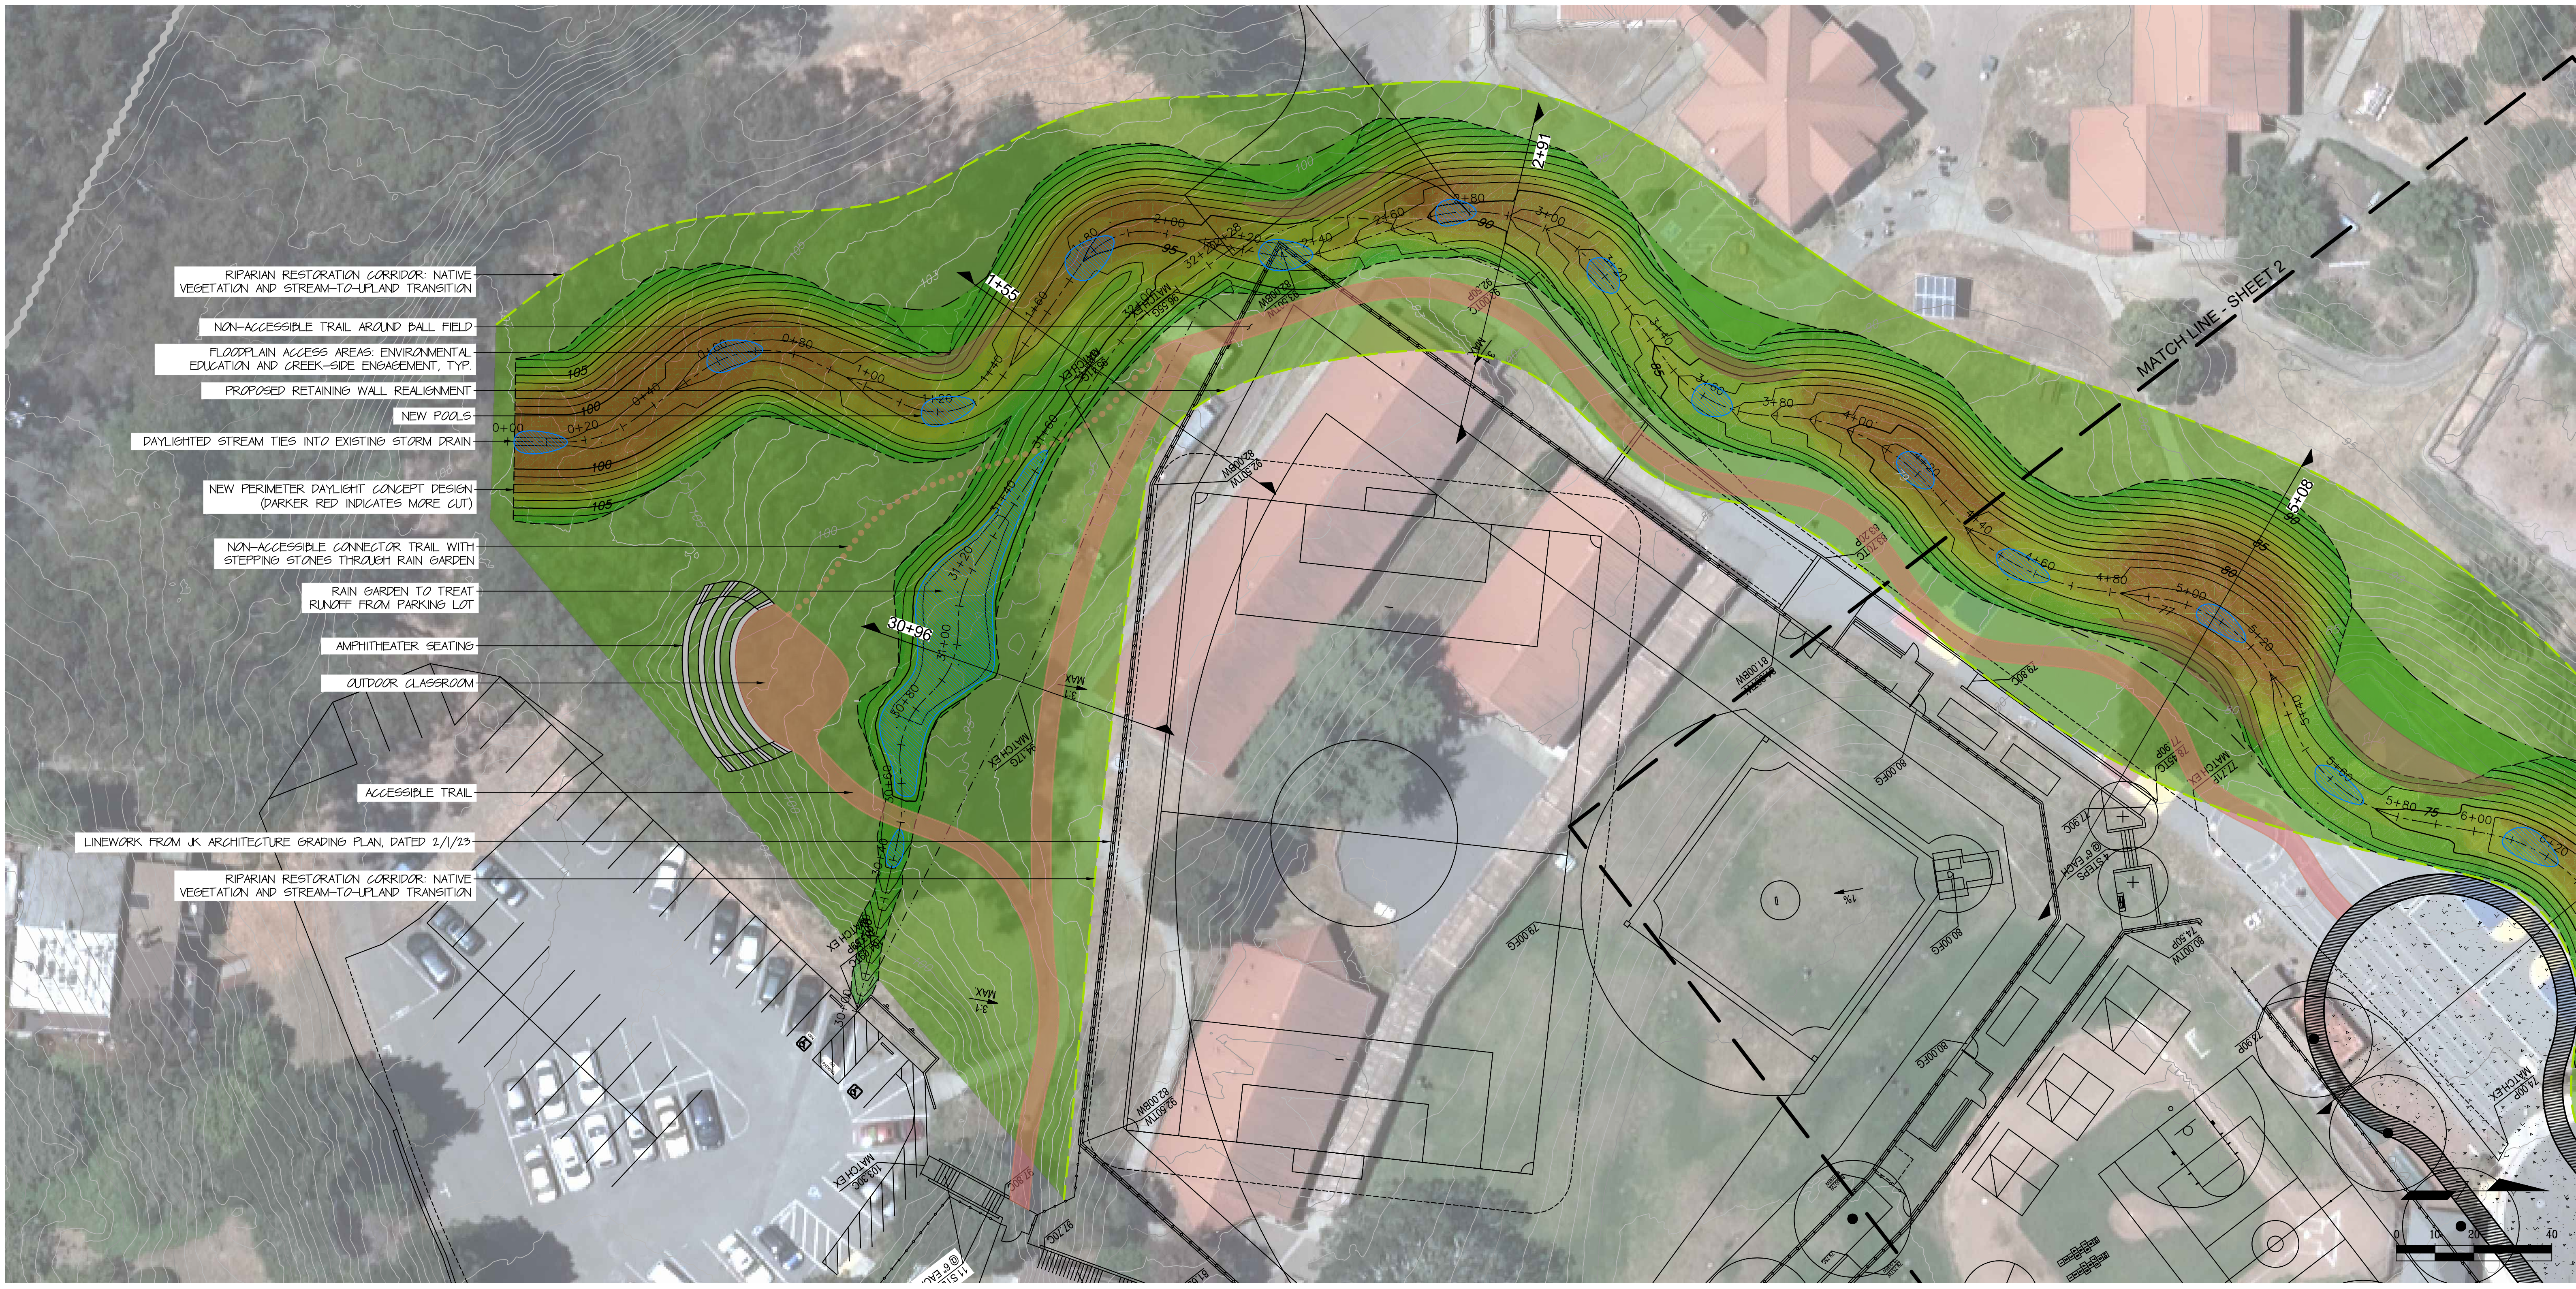


STREAM CENTERLINE PROFILE

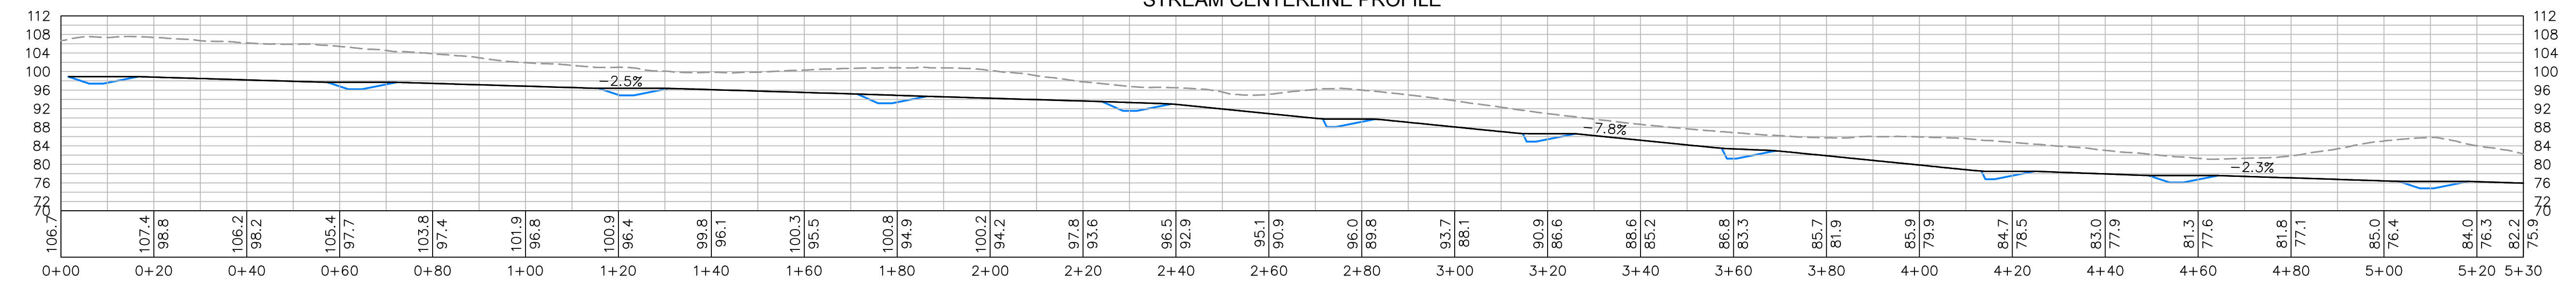


RAIN GARDEN CL PROFILE

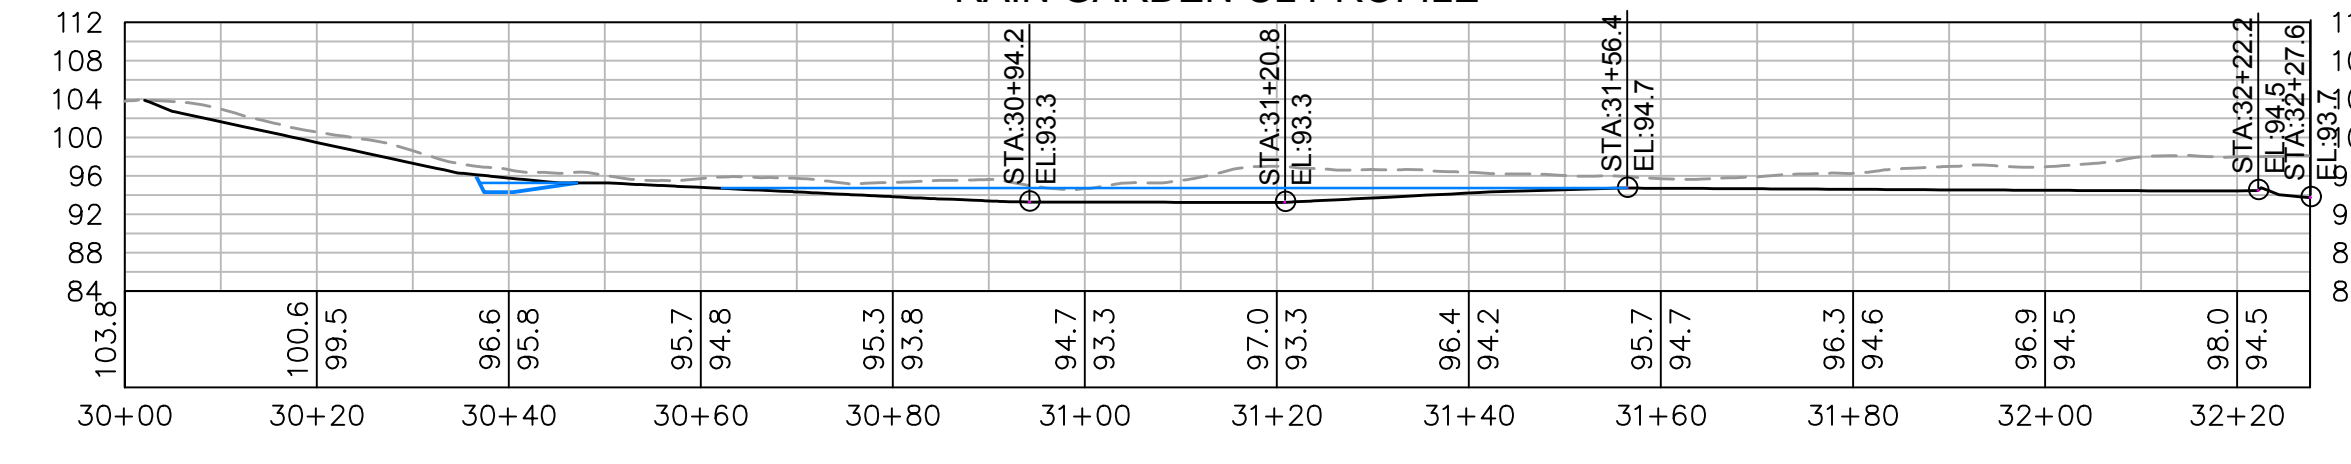


1+55

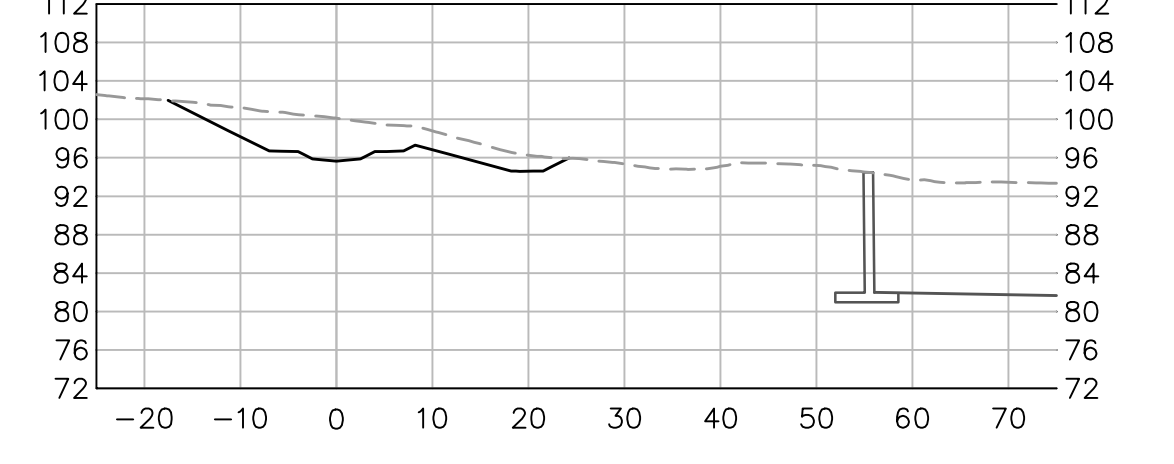

30+96
PROPOSED RETAINING WALL AND BALL FIELD PER JKA PLAN (TYP.)

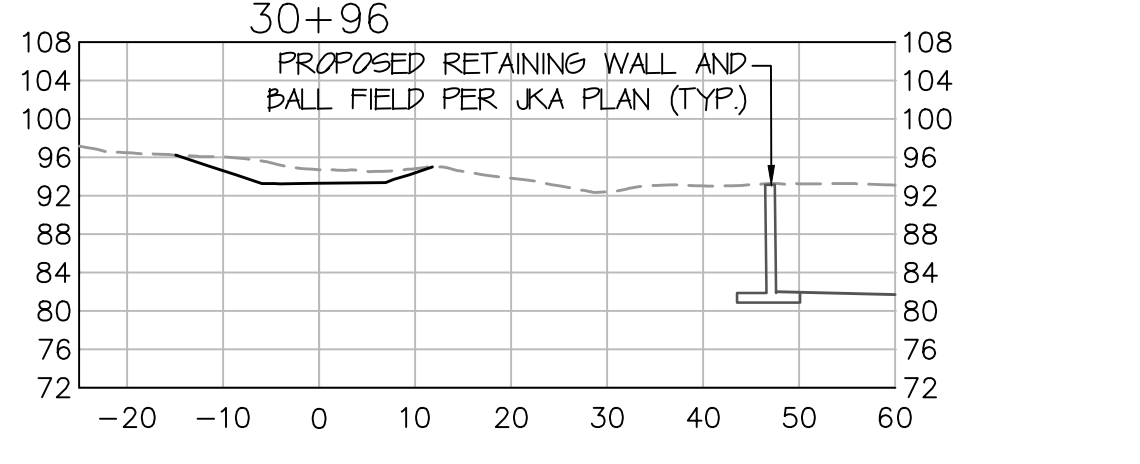

2+91

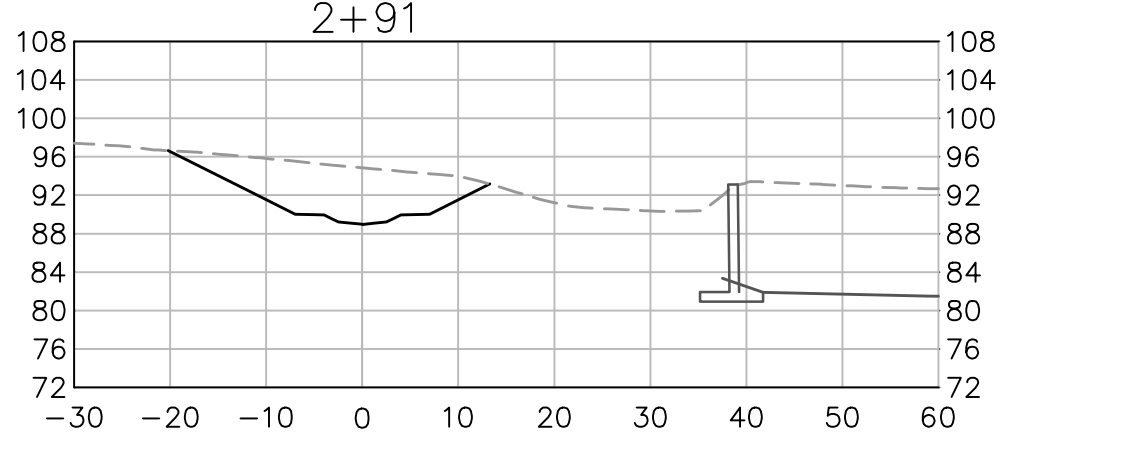

VERIFY SCALES
ONE INCH

Acad File Name: G:\Acad Drawings\2023\Willow Creek\Drawings\PP.dwg
Plot Date: 4/21/2023 2:54 PM
Layout: PPI - PLAN AND PROFILE

